

SYMBOL LEGEND

	Outlet
	240 Volt Outlet
	GFCI Outlet
	Cable TV Outlet
	Garbage Disposal
	Data
	Smoke Detector
	Steam Shower Generator
	Exhaust Fan
	Floor Outlet
	2 Way Switch Dimmer
	3 Way Switch Dimmer
	Single Switch
	Chandelier
	Hall Sconce
	Master Bath Sconce
	6\"/>
	3\"/>
	Pendant Light
	Tape Light
	Wall Finish
	Flooring
	Furniture
	Hard Surface
	Plumbing
	Appliance

ABBREVIATIONS

A.F.F Above Finished Floor	QTY Quantity
DIA Diameter	RCP Reflected Ceiling Plan
DIM Dimension	
N North	
NTS Not to Scale	



FOLKWRIGHT
spaces

FolkWright Spaces

Claudia Folk Wright

Interior Designer
folk.claudia@gmail.com
(719) 244-7825
www.folkwrightspaces.weebly.com

CD COVER
PAGE

SHEET INDEX

A1.0 As-Built Plan
A1.1 Demolition Plan
A1.2 Construction Plan
A1.3 Furnishing Plan
A1.4 Finish Plan
A1.5 RCP/Lighting Plan
A1.6 Electrical Plan
A2.1 Window Elevation
A2.2 Wall Elevation
A5.1 Island Plan Detail
A5.2 Island Section Detail
A5.3 Island Elevation Detail
A6.1 Furniture Schedule
A6.2 Finish Schedule

PROJECT CONTACTS

DESIGNER: CLAUDIA FOLK WRIGHT
719.244.7825

PROJECT MANAGER

ARCHITECT


CLIENT: DIANE JOHNSON

PROJECT:
Heritage School
of Interior Design
AutoCAD Final Project


6/28//2019

PAGE

A0.0

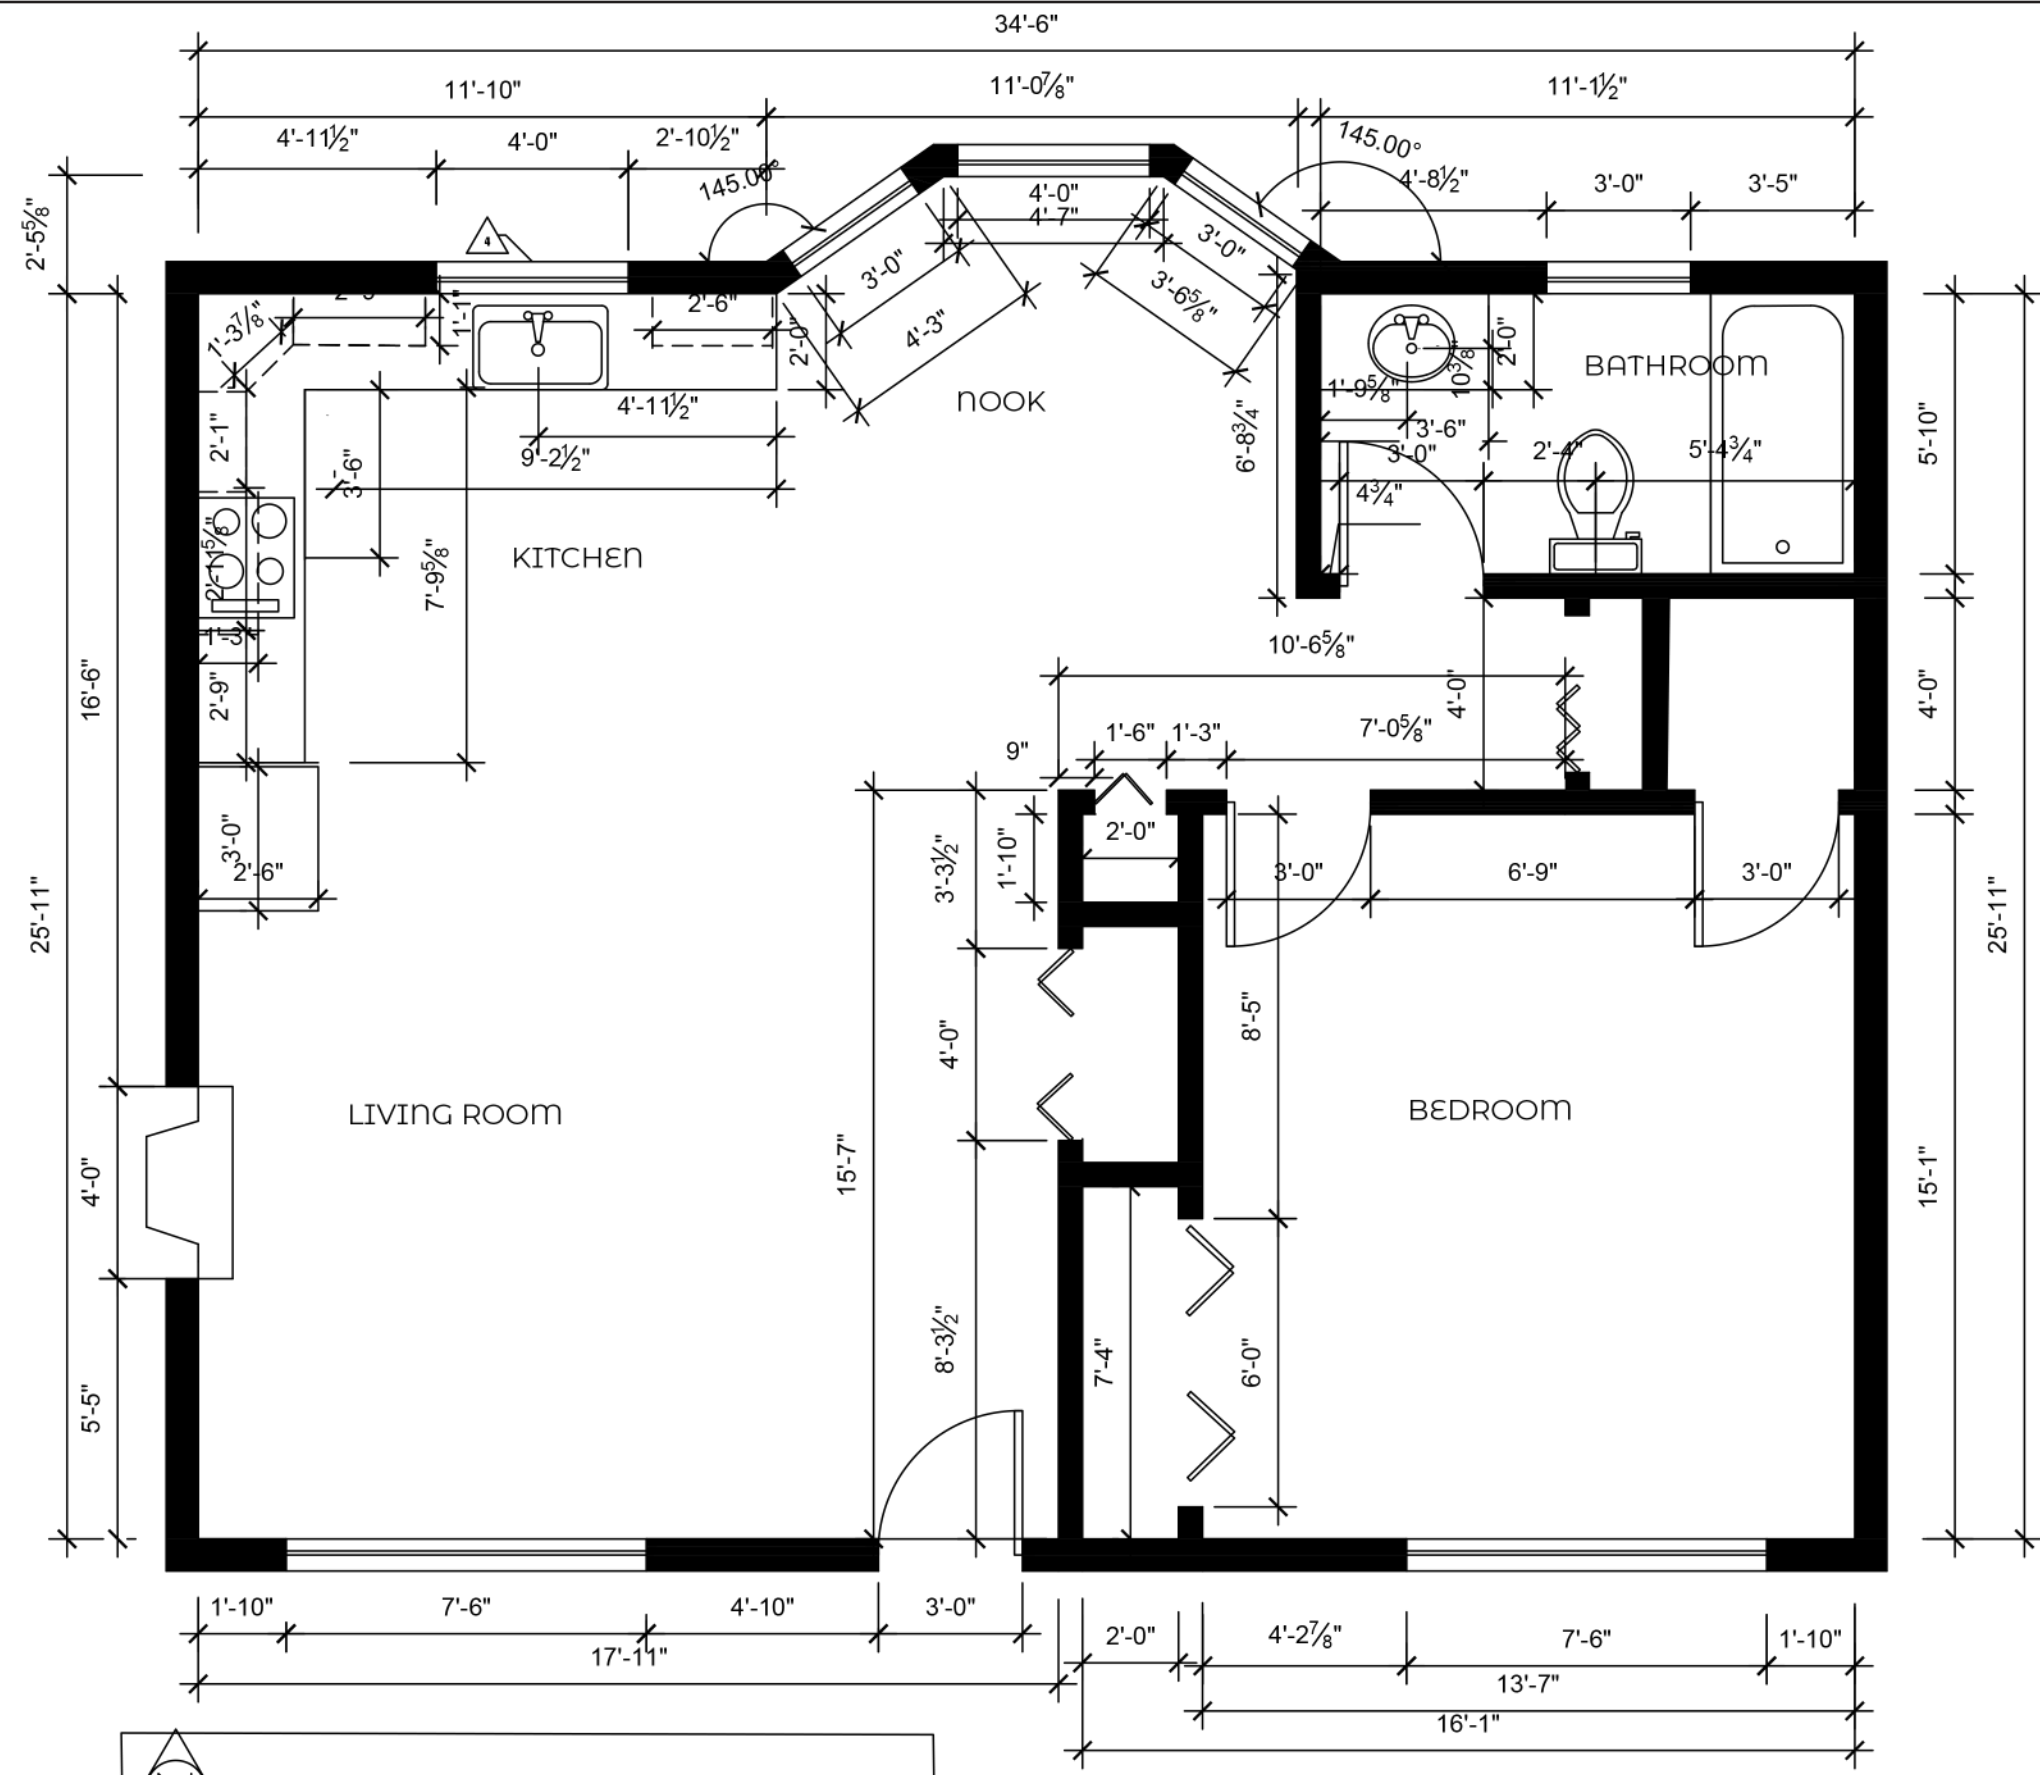

- KEYED NOTES**
- 1 Gas Fireplace
 - 2 Ceiling Height is 10'-0"
 - 3 Window Height is 48" and 36" A.F.F. For all windows, other than kitchen window
 - 4 Kitchen Window Height 36" and 48" A.F.F.
 - 5 Door Heights: 80" for all doors
 - 6 Washer and dryer hook ups and vent

 BUNGALOW AS-BUILT PLAN
Scale: 1/4"=1'-0"
CLAUDIA FOLK WRIGHT


**JOHNSON
DEMOLITION
PLAN**

PROJECT:
Heritage School
of Interior Design
AutoCAD Final Project

6/19/2019

PAGE


A1.1

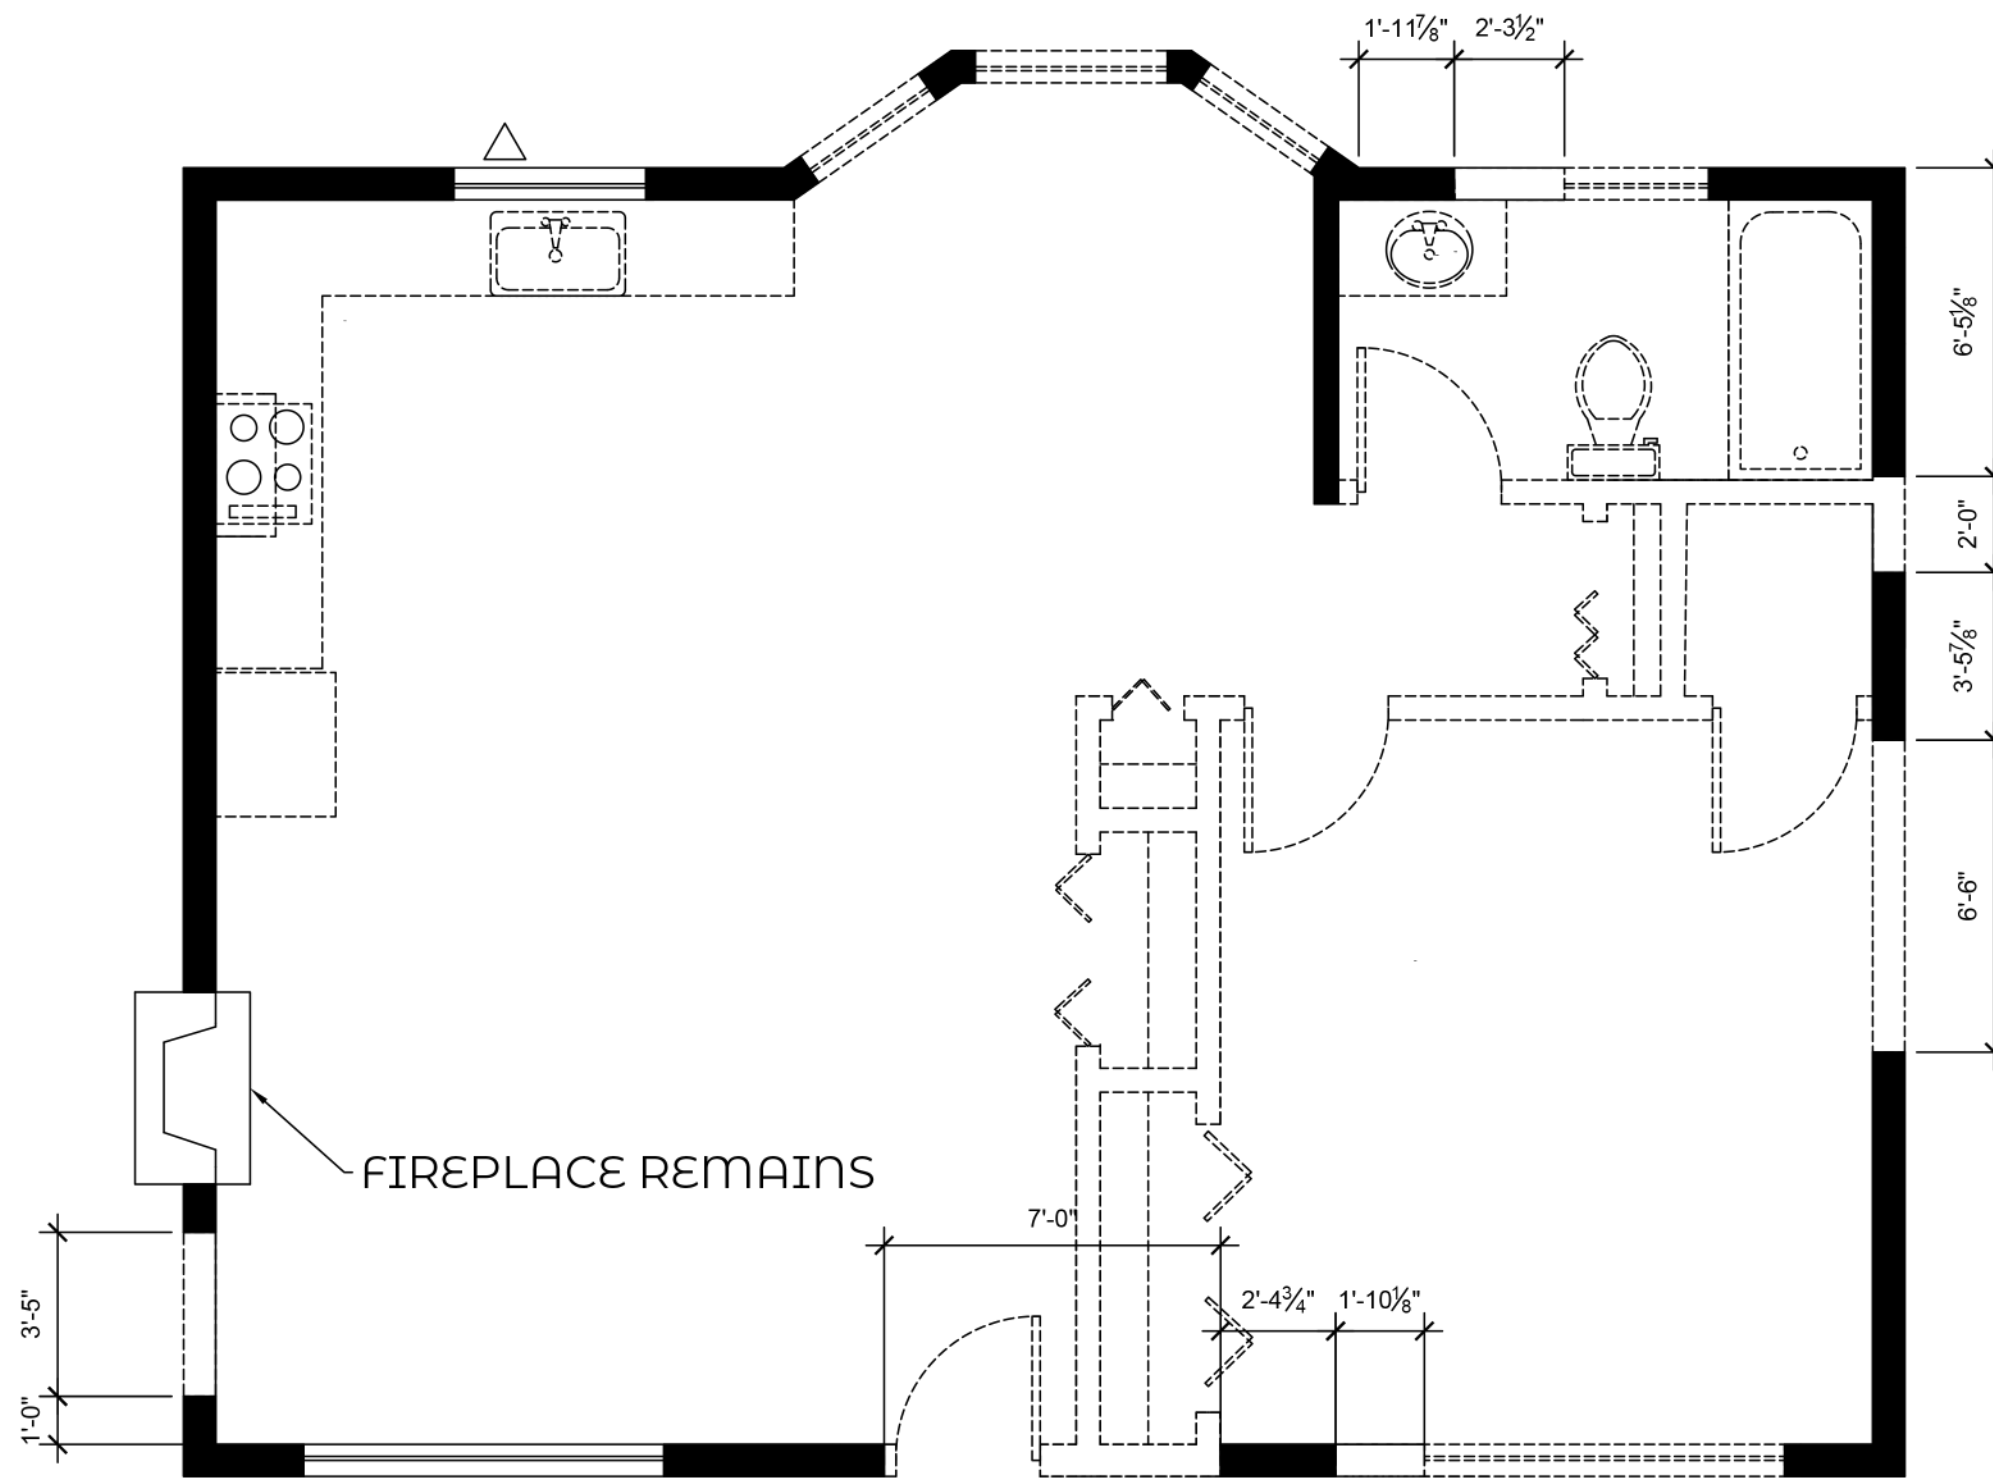


FIREPLACE REMAINS

JOHNSON DEMOLITION PLAN
Scale: 1/4"=1'-0"
CLAUDIA FOLK WRIGHT

EXISTING WALL TO REMAIN = **█**
DEMOLITION LINES = **- - - - -**
EXTERIOR WALLS = 8"
INTERIOR WALLS = 6"

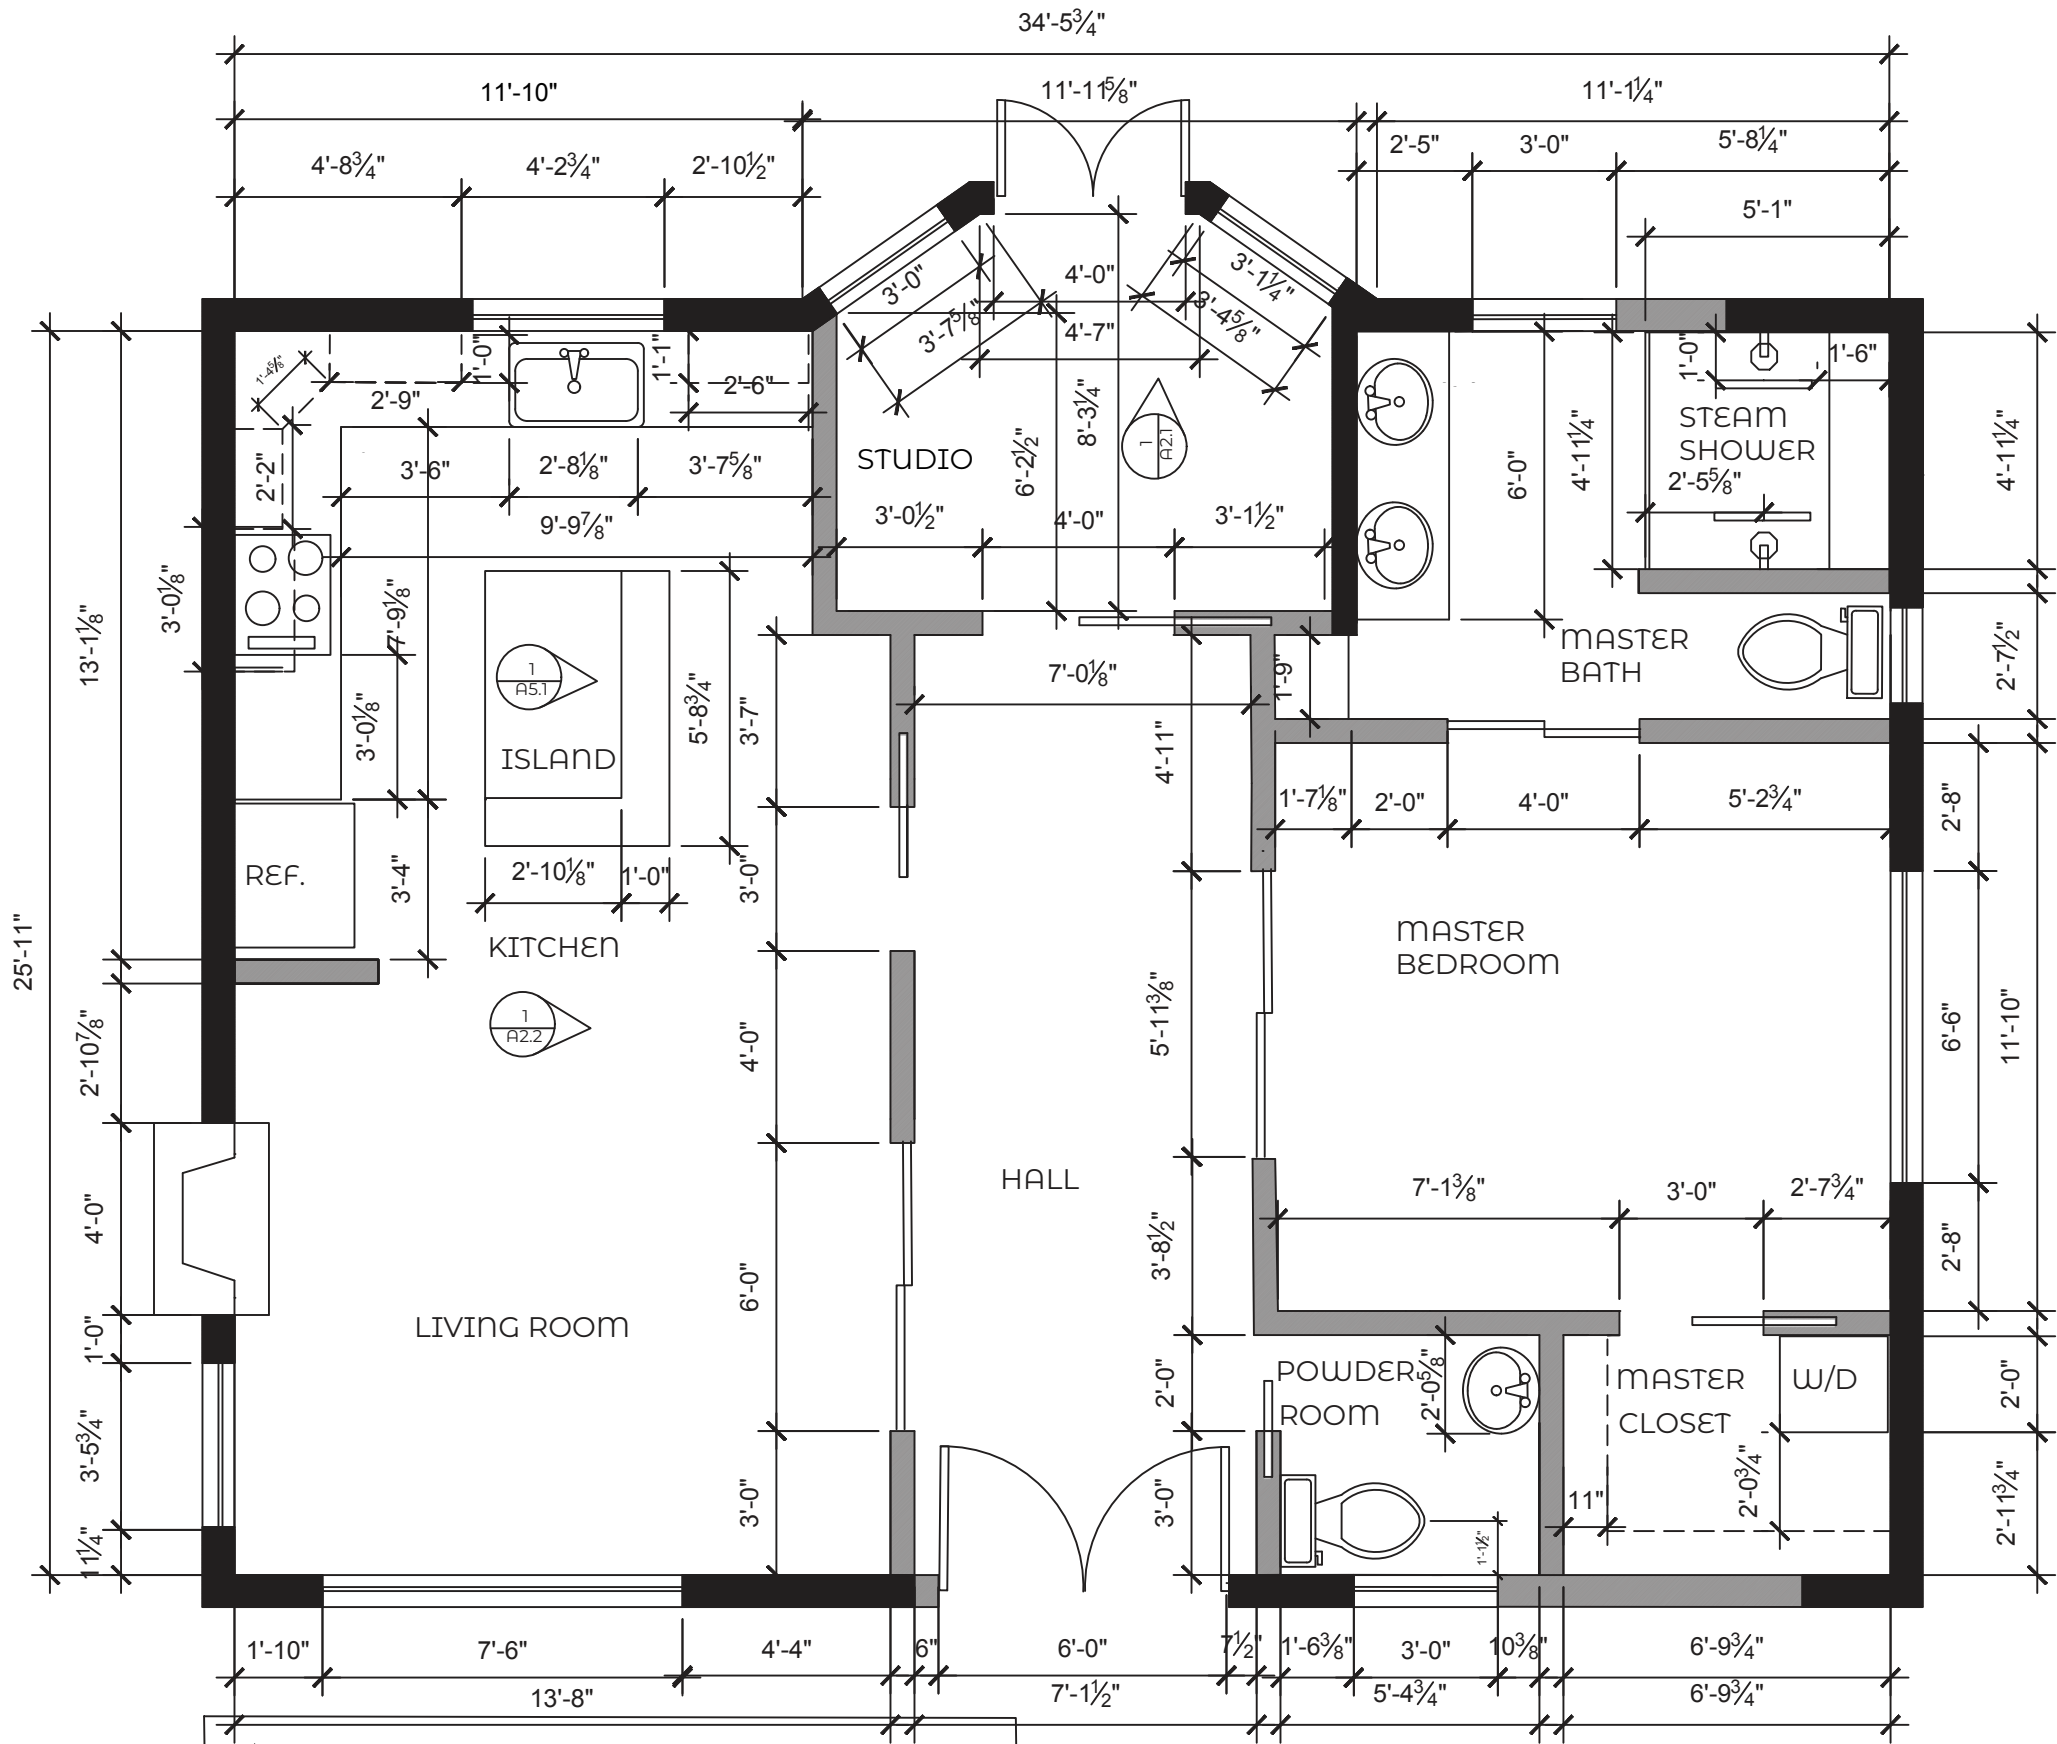


JOHNSON CONSTRUCTION PLAN
 Scale: 1/4"=1'-0"
 CLAUDIA FOLK WRIGHT

FolkWright Spaces
 Claudia Folk Wright
 Interior Designer
 folk.claudia@gmail.com
 (719) 244-7825
 www.folkwrightspaces.weebly.com

JOHNSON
Construction
Plan

PROJECT:
 Heritage School
 of Interior Design
 AutoCAD Final Project

6/19/2019

FolkWright Spaces

Claudia Folk Wright
Interior Designer
folk.claudia@gmail.com
(719) 244-7825
www.folkwrightspaces.weebly.com


JOHNSON FURNITURE PLAN

PROJECT:
Heritage School
of Interior Design
AutoCAD Final Project

6/19/2019

PAGE

A1.3

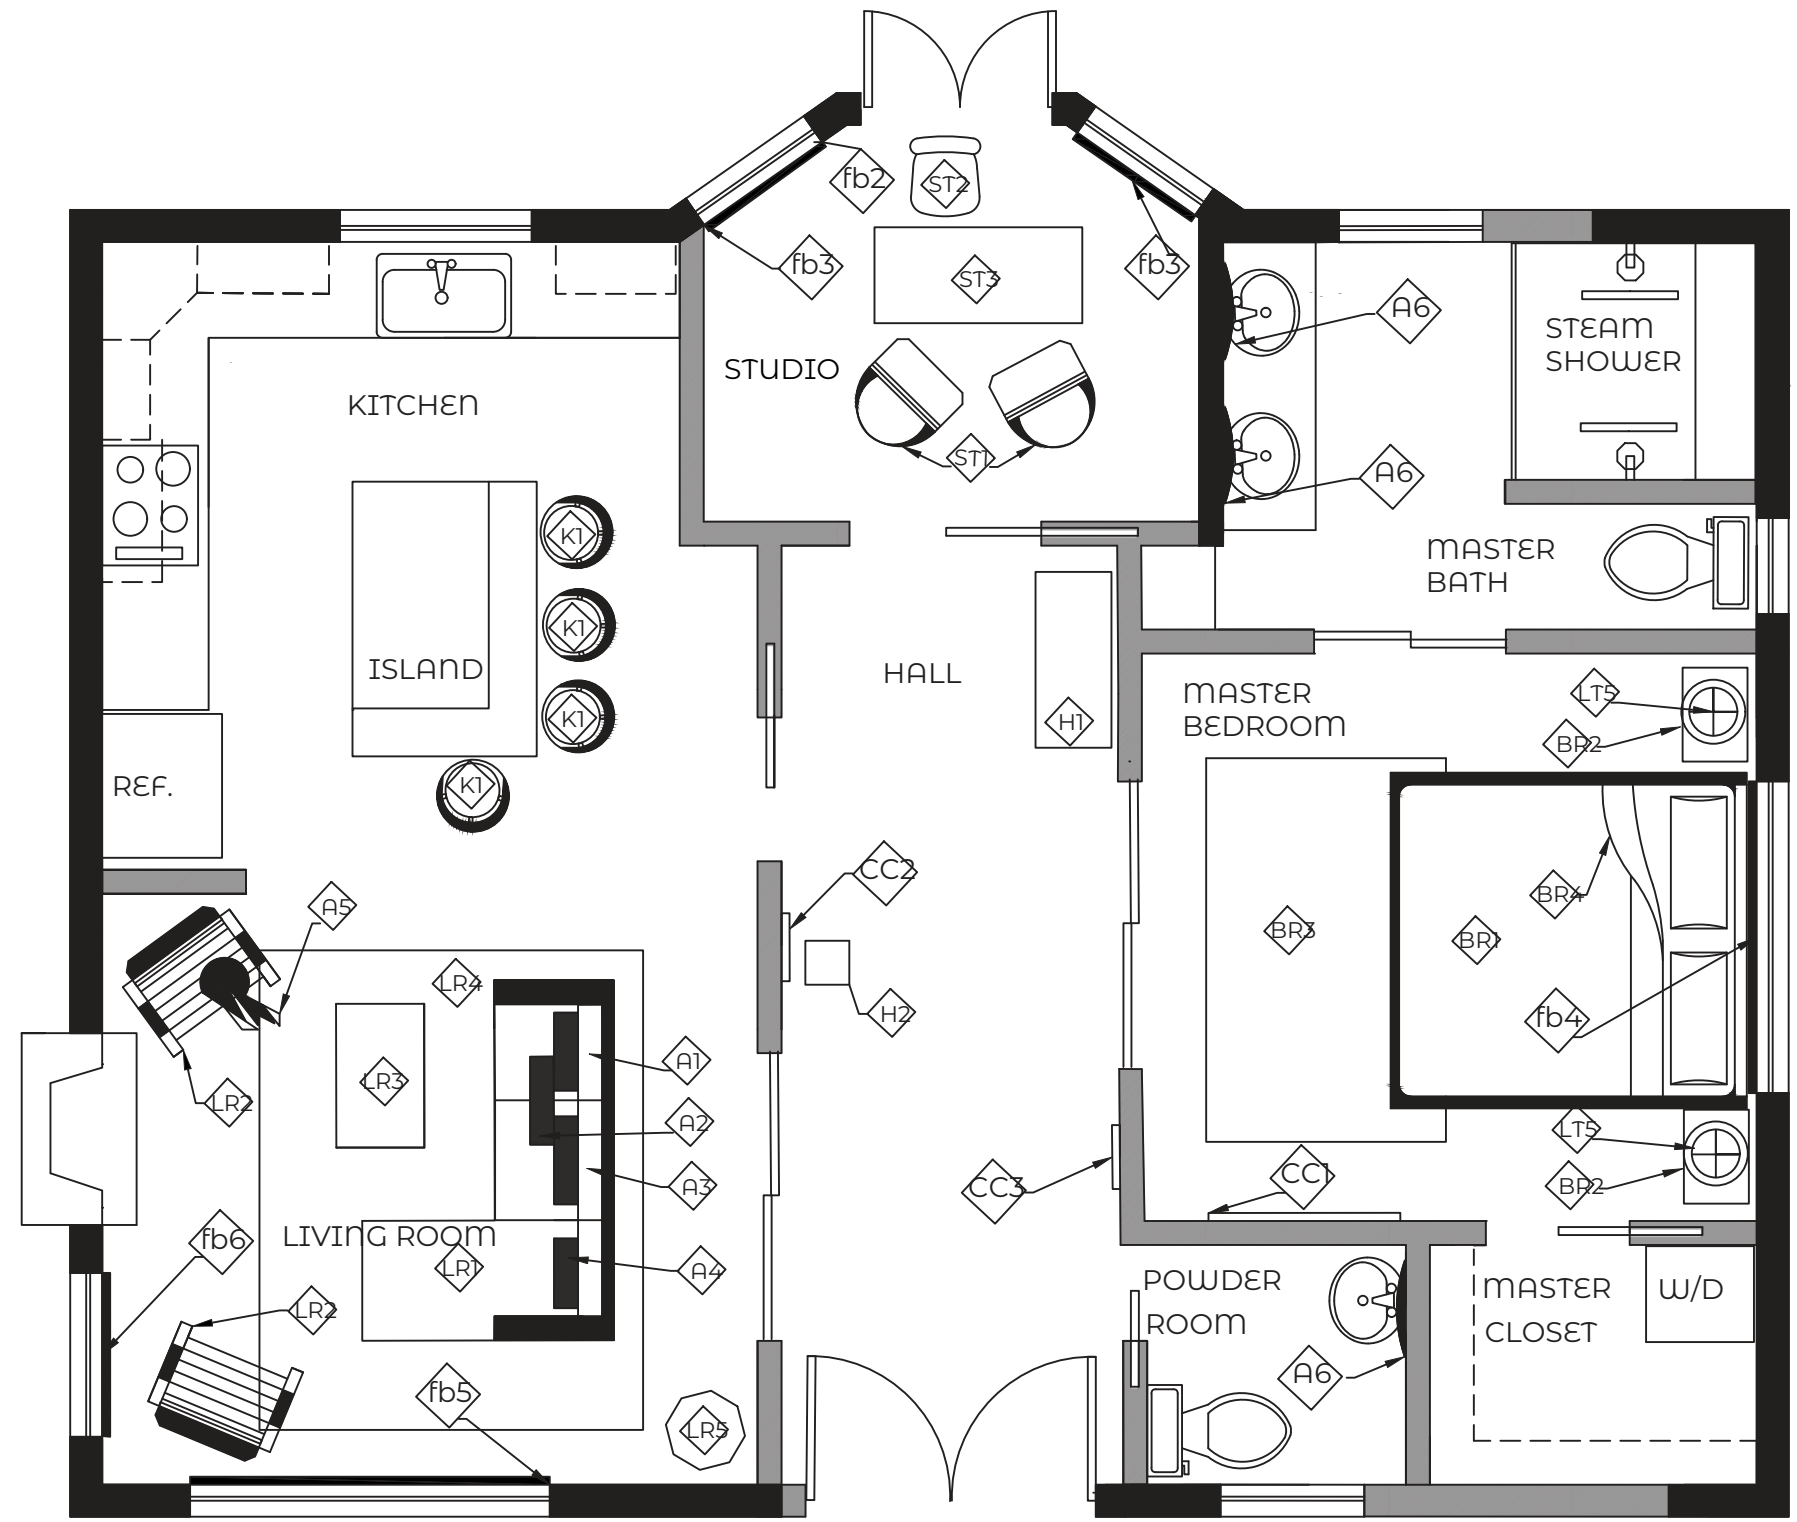


N JOHNSON FURNITURE PLAN
Scale: 1/4"=1'-0"
CLAUDIA FOLK WRIGHT

**JOHNSON
FINISH PLAN**

PROJECT:
Heritage School
of Interior Design
AutoCAD Final Project

6/19/2019

PAGE
A1.4

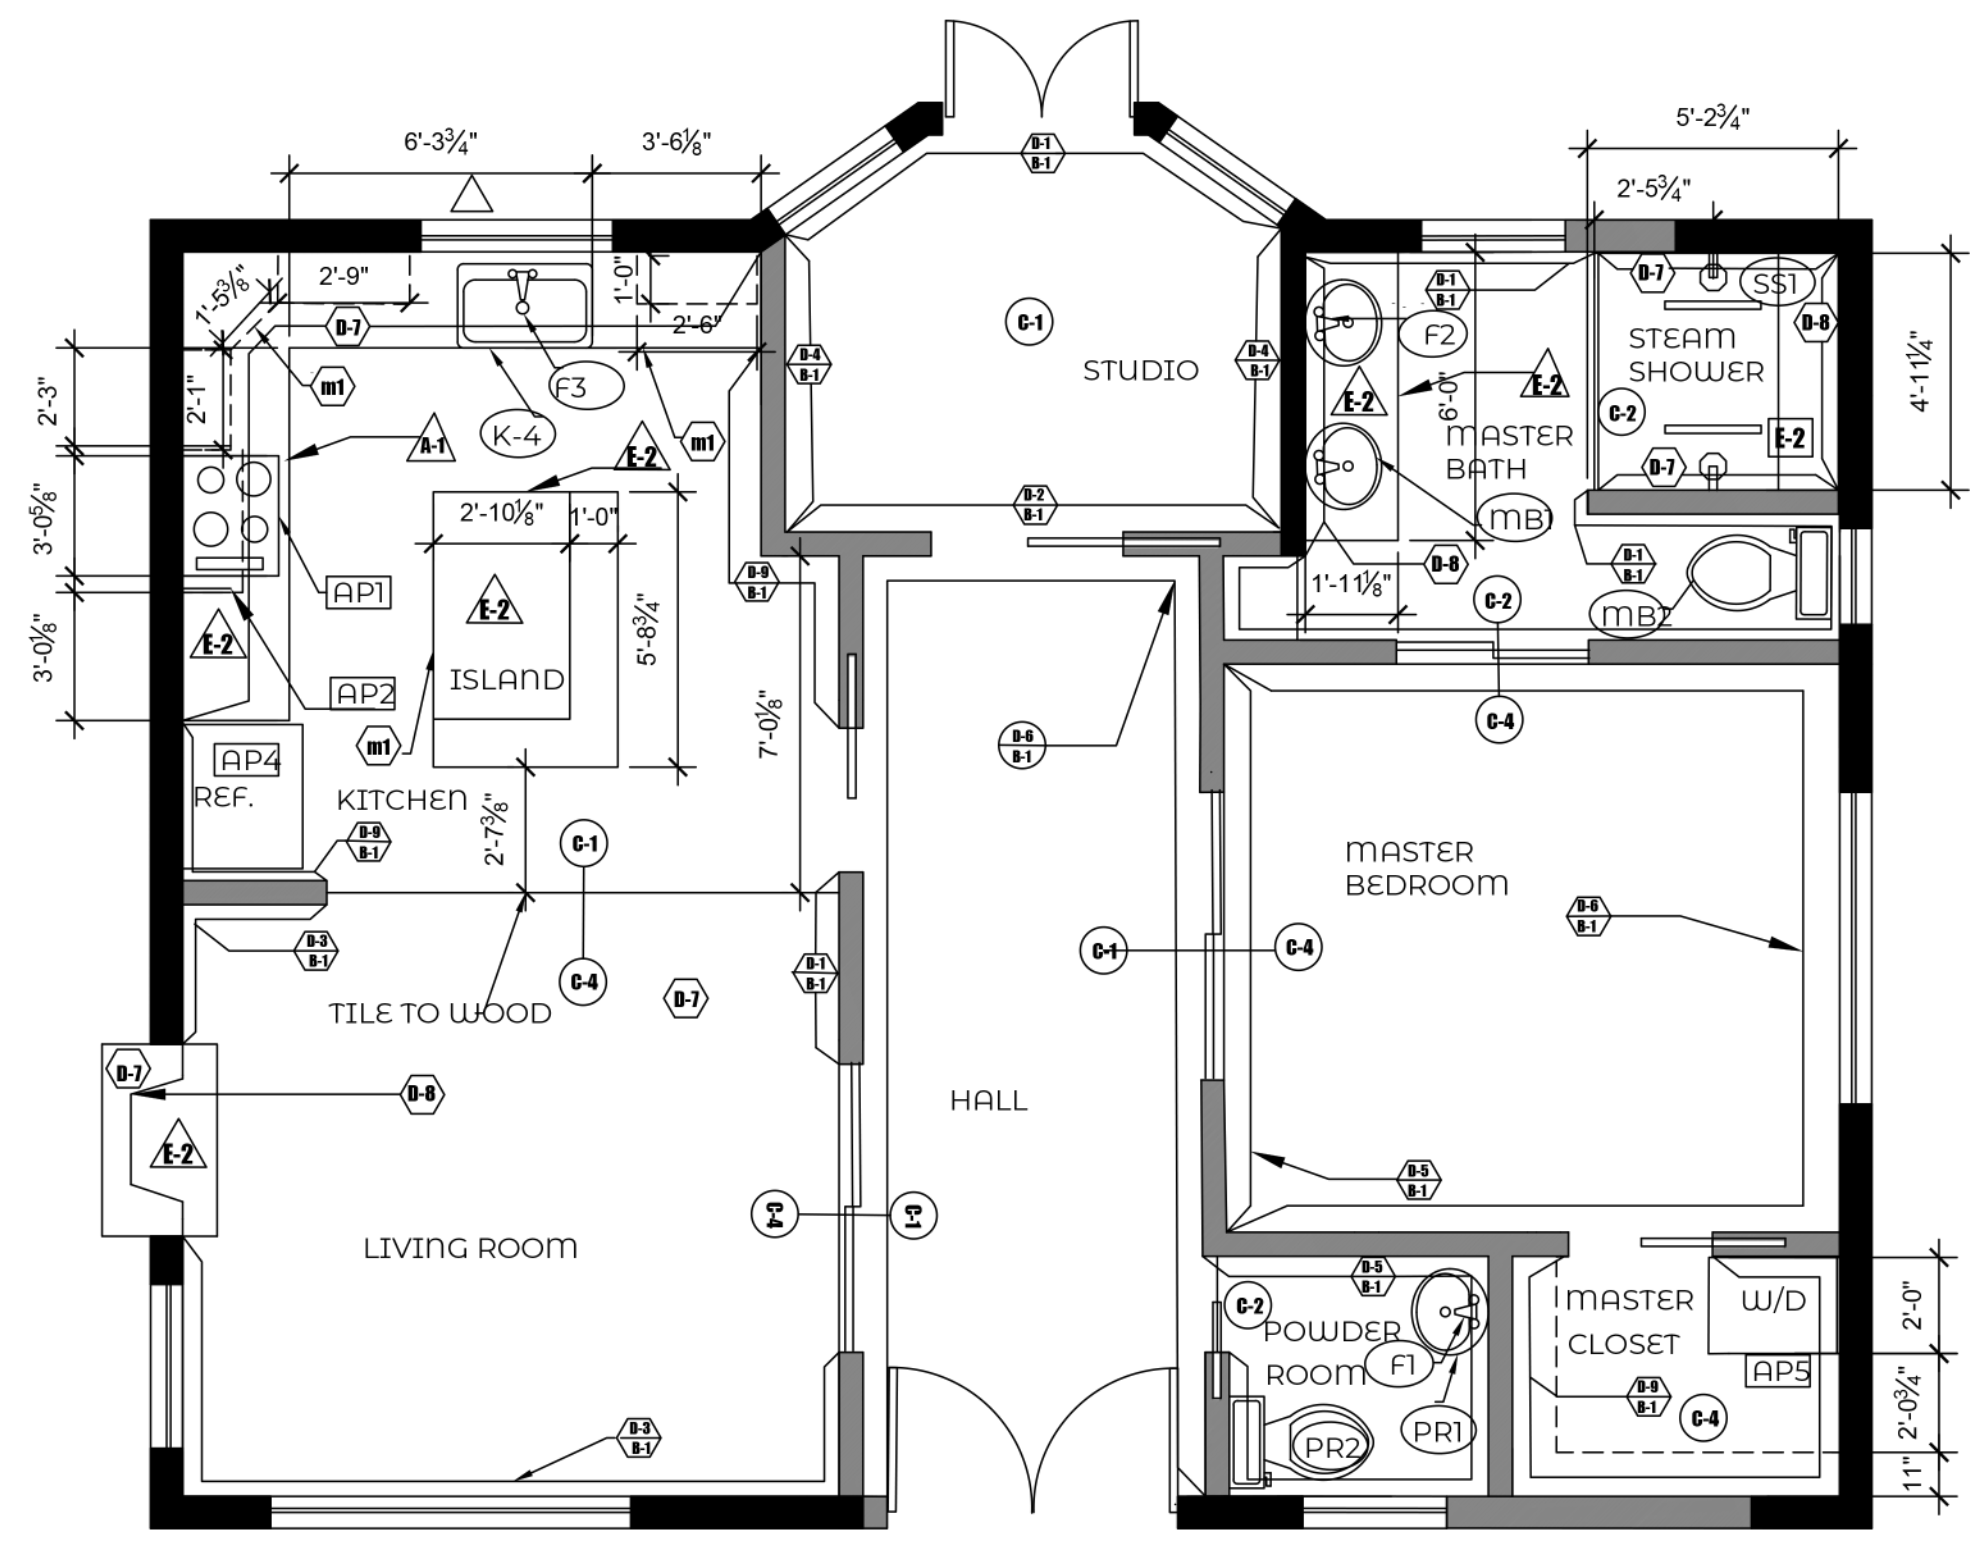

JOHNSON FINISH PLAN
Scale: 1/4" = 1'-0"
CLAUDIA FOLK WRIGHT


JOHNSON
RCP/LIGHTING
PLAN

PROJECT:
Heritage School
of Interior Design
AutoCAD Final Project

6/19/2019

PAGE

A1.5

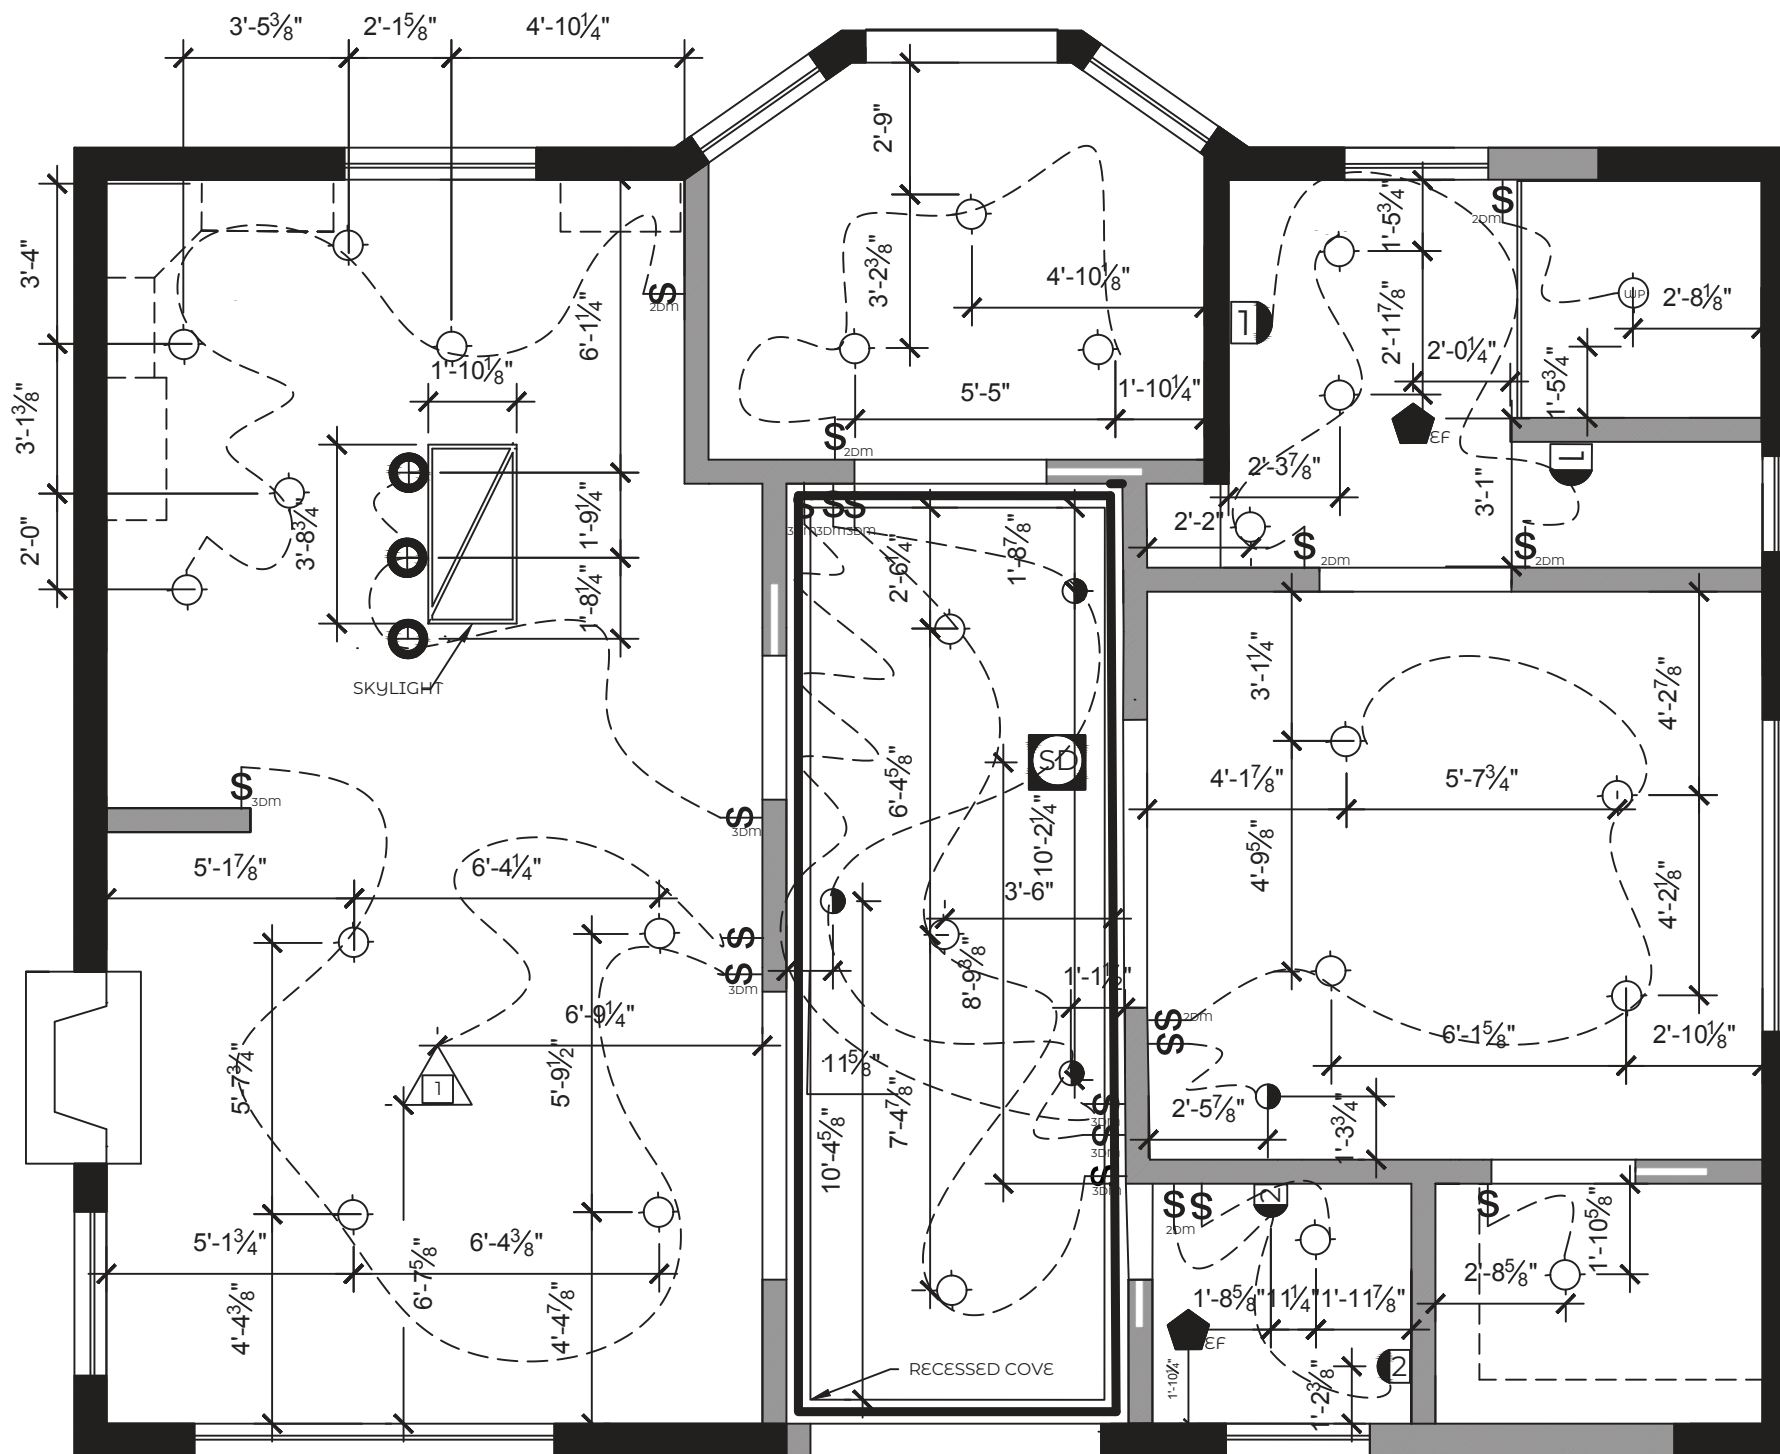

LIGHTING/SWITCH LEGEND	
$\$_{2DM}$	2 Way Switch Dimmer
$\$_{3DM}$	3 Way Switch Dimmer
$\$$	Single Switch
\triangle	Chandelier
\square	Hall Sconce
\square	Master Bath Sconce
\circ	6" Recessed Can Light
\bullet	3" Spotlight
\oplus	Pendant Light
---	Tape Light
\square_{SD}	Smoke Detector
\blacktriangledown_{EF}	Exhaust Fan

N JOHNSON RCP/LIGHTING PLAN
Scale: 1/4"=1'-0"
CLAUDIA FOLK WRIGHT

CEILING HEIGHT = 10'-0"


**JOHNSON
ELECTRICAL
PLAN**

PROJECT:
Heritage School
of Interior Design
AutoCAD Final Project

6/19/2019

PAGE

A1.6

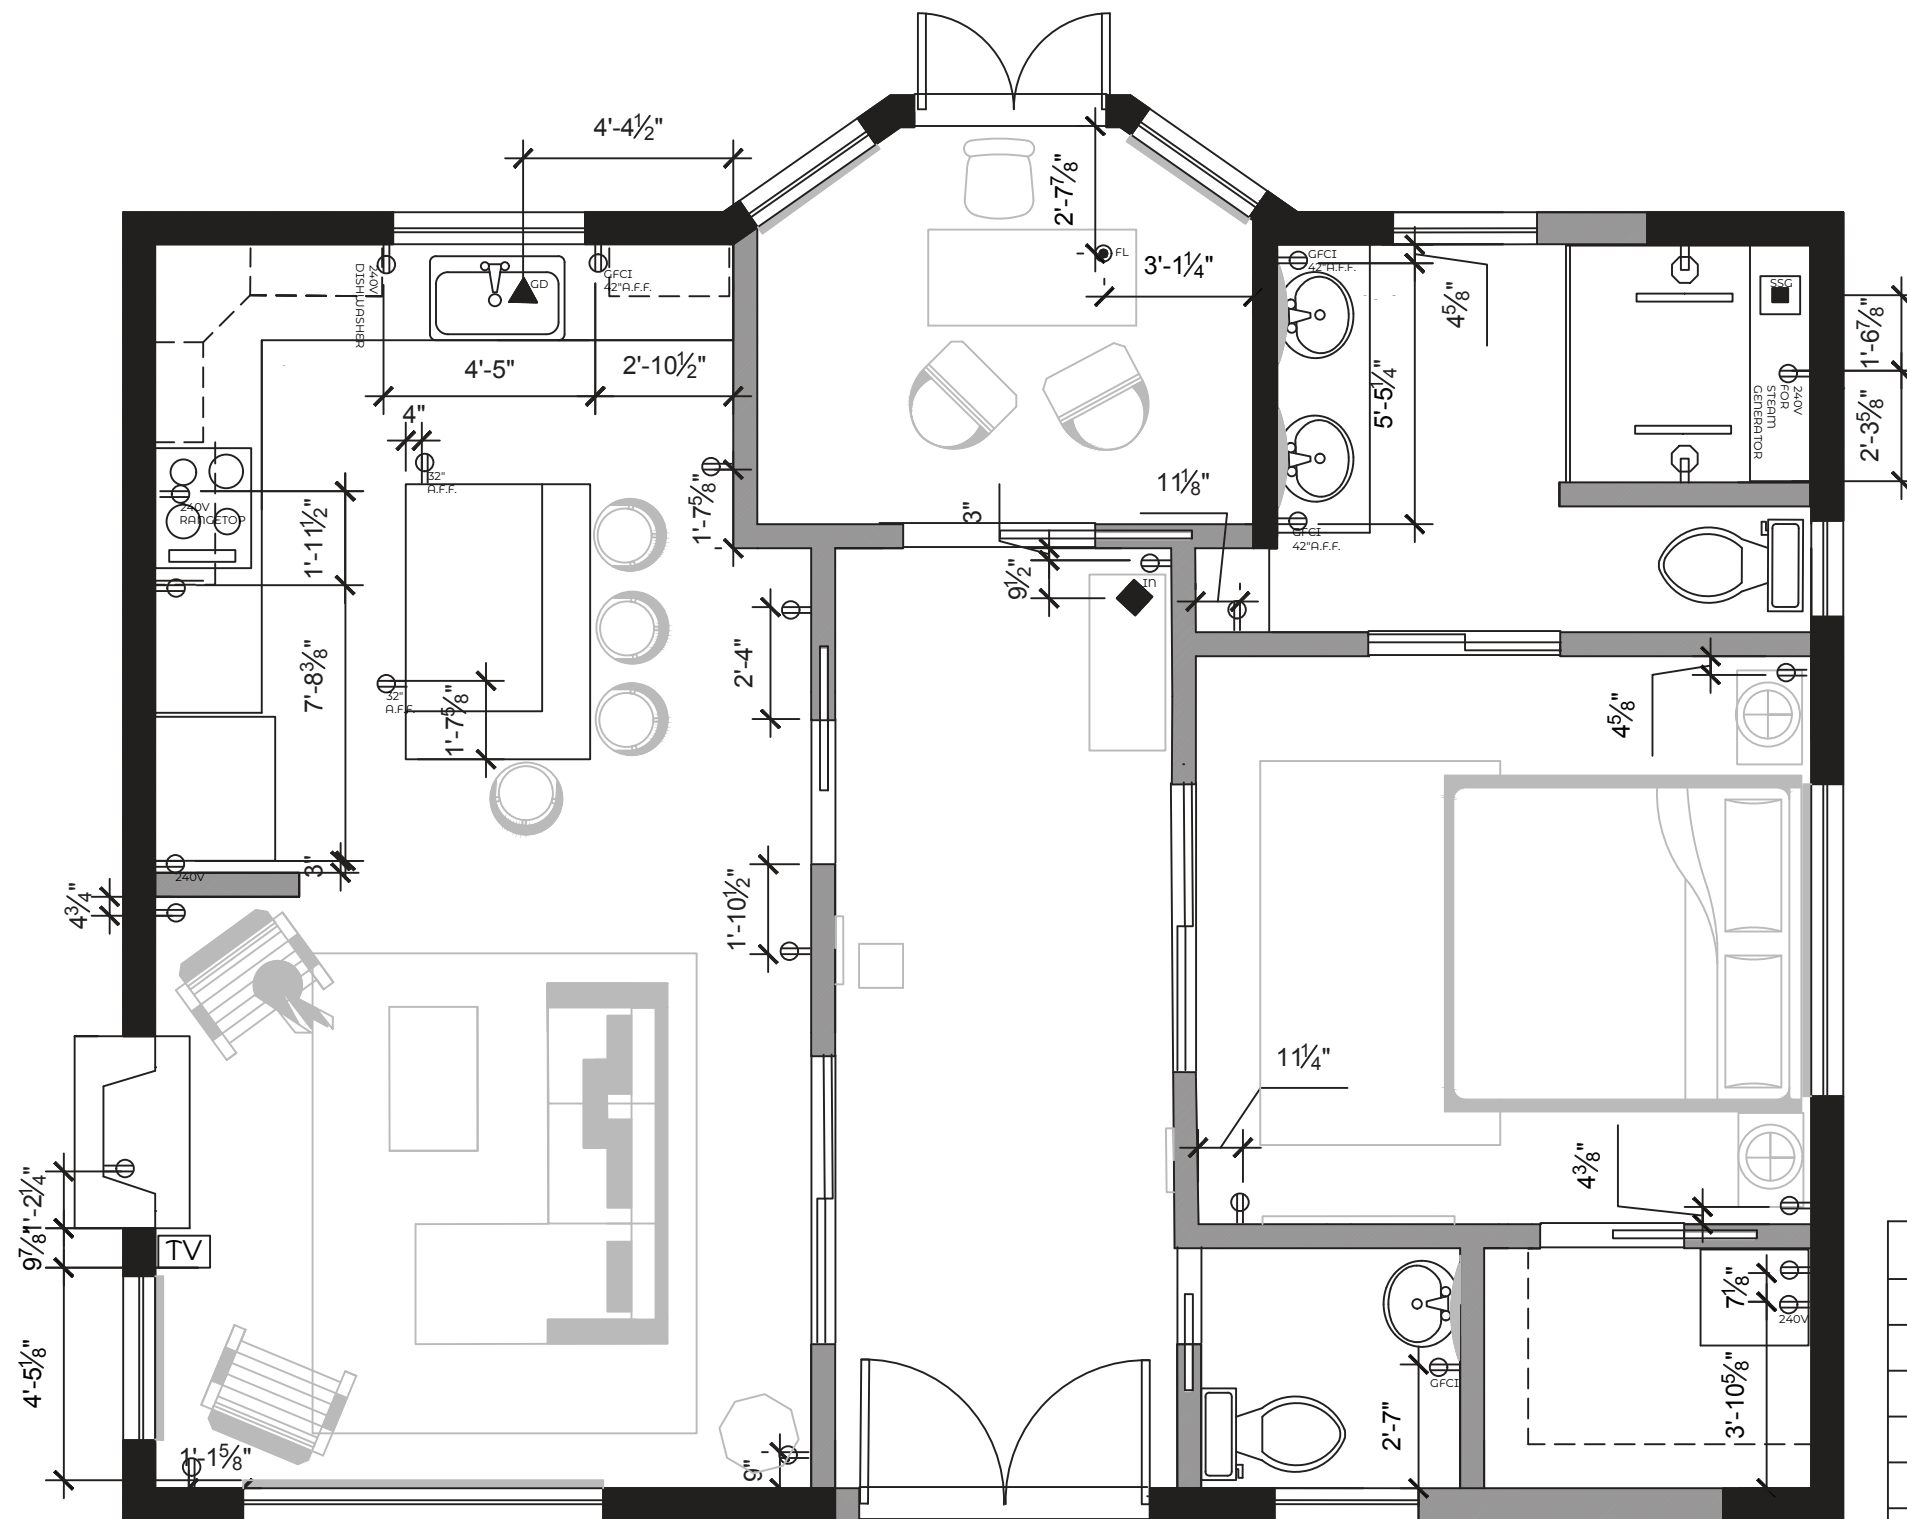

ELECTRICAL LEGEND	
	Outlet
	240 Volt Outlet
	GFCI Outlet
	Cable TV Outlet
	Garbage Disposal
	Data
	Floor Outlet
	Steam Shower Generator


JOHNSON ELECTRICAL PLAN
Scale: 1/4"=1'-0"
CLAUDIA FOLK WRIGHT

CEILING HEIGHT = 10'-0"
OUTLETS = 1'-0" A.F.F. TYP.


**JOHNSON
WINDOW
ELEVATION**

PROJECT:
Heritage School
of Interior Design
AutoCAD Final Project

6/27/2019

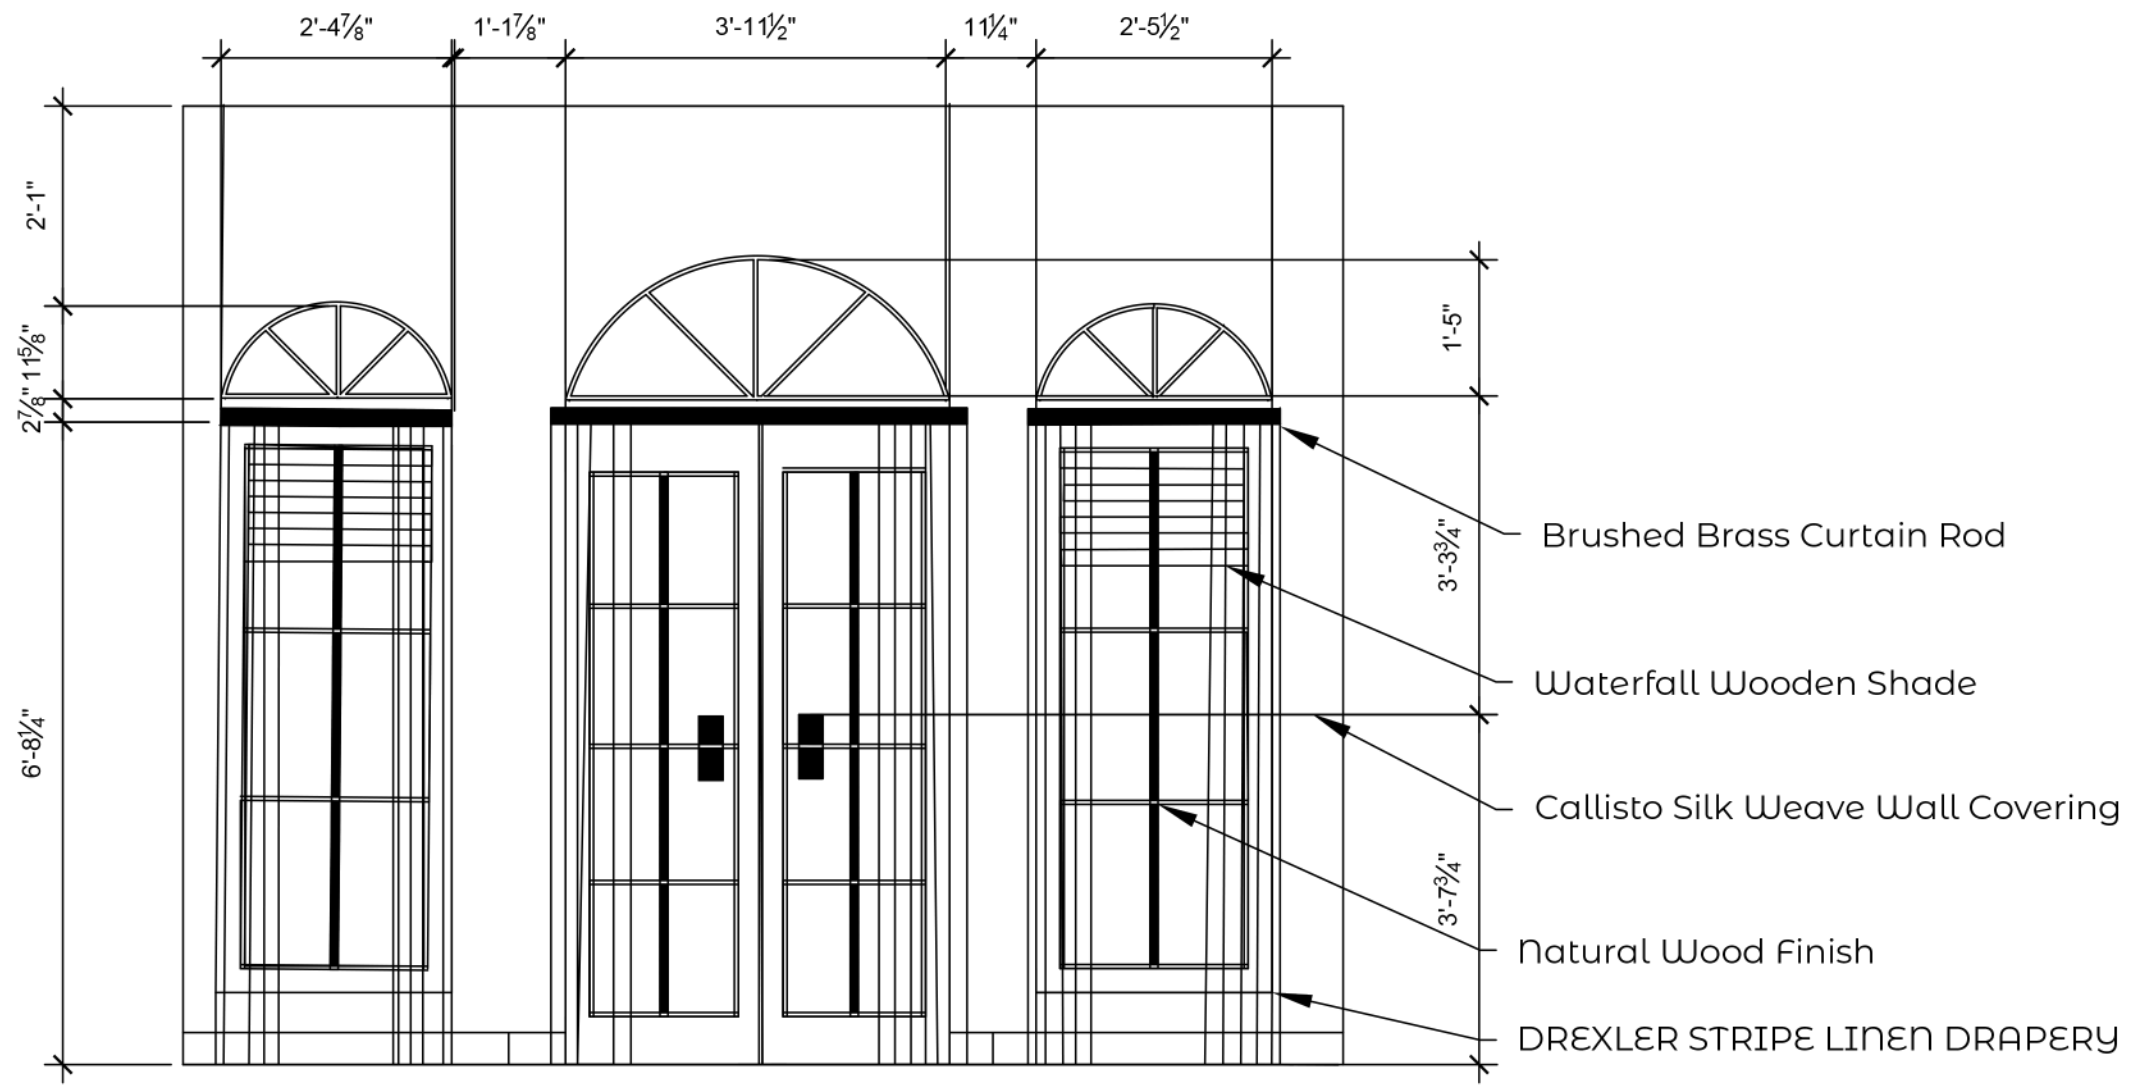

JOHNSON WINDOW ELEVATION
Scale: 1/2"=1'-0"
CLAUDIA FOLK WRIGHT

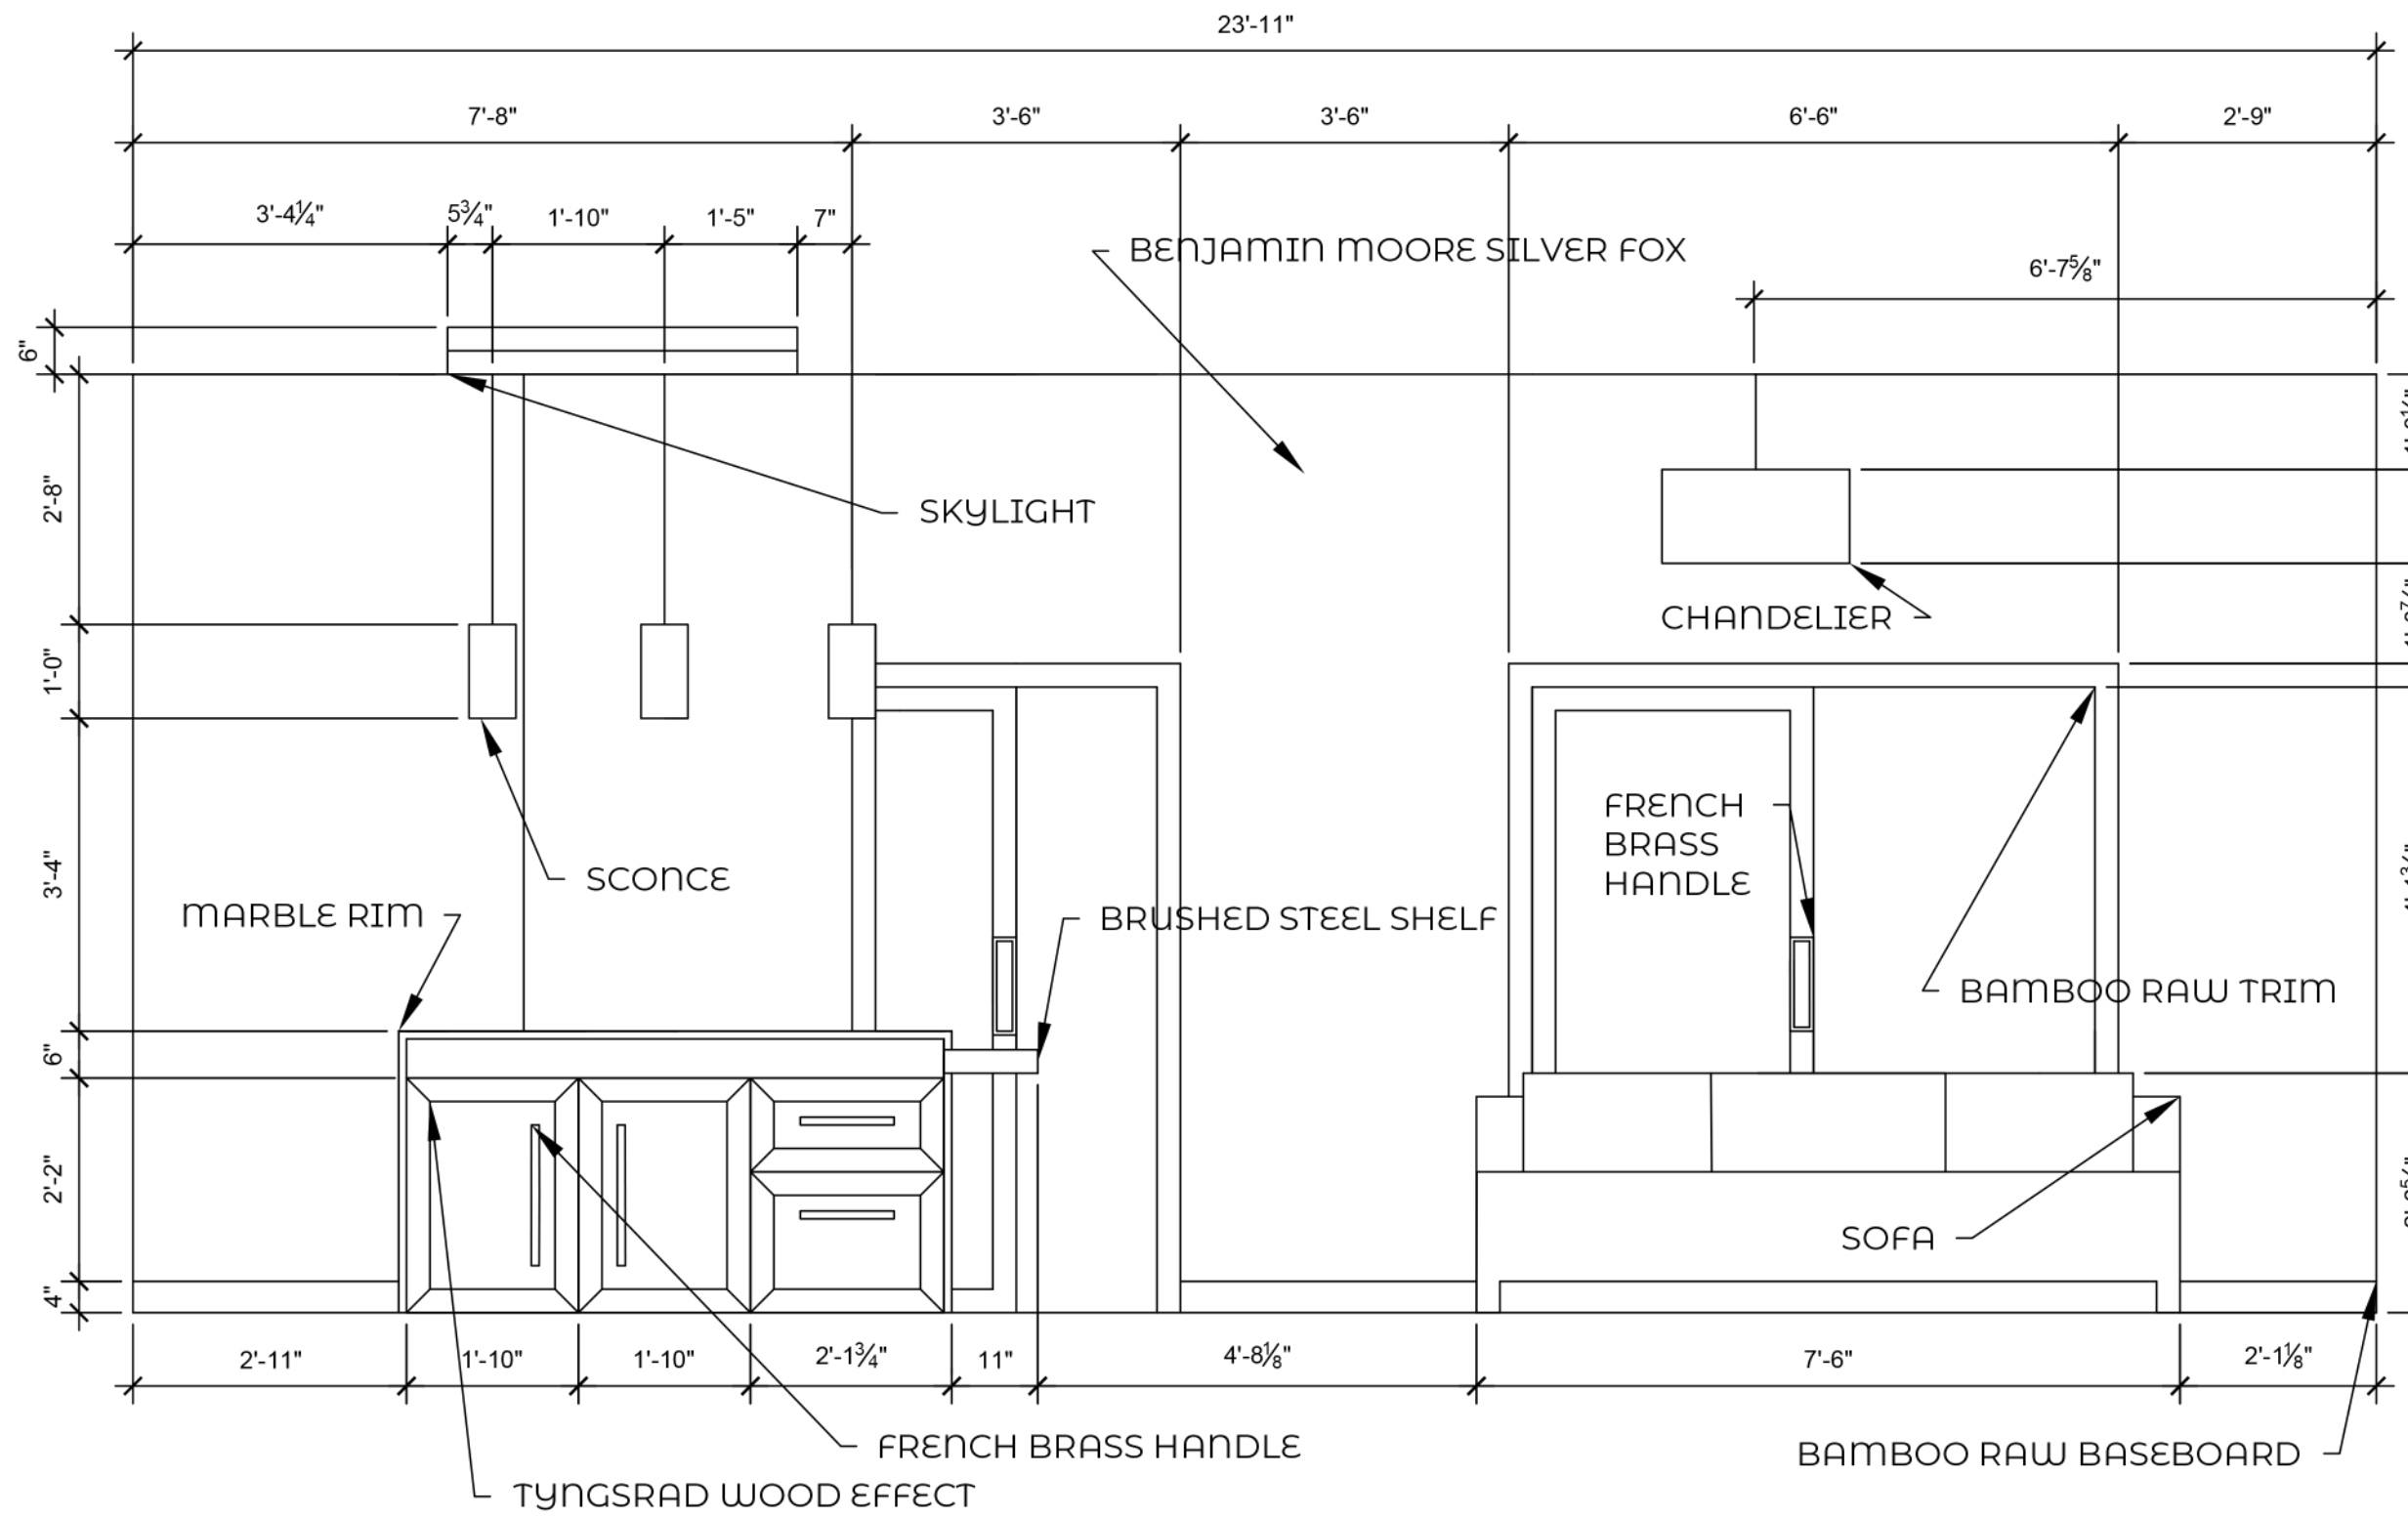

JOHNSON
WALL
ELEVATION

PROJECT:
Heritage School
of Interior Design
AutoCAD Final Project

6/27/2019

PAGE

A2.2

JOHNSON WALL ELEVATION
Scale: 1/2"=1'-0"
CLAUDIA FOLK WRIGHT

FolkWright Spaces

Claudia Folk Wright
Interior Designer
folk.claudia@gmail.com
(719) 244-7825
www.folkwrightspaces.weebly.com


ISLAND
DETAIL PLAN
VIEW

PROJECT:
Heritage School
of Interior Design
AutoCAD Final Project

6/27/2019

PAGE

A5.1

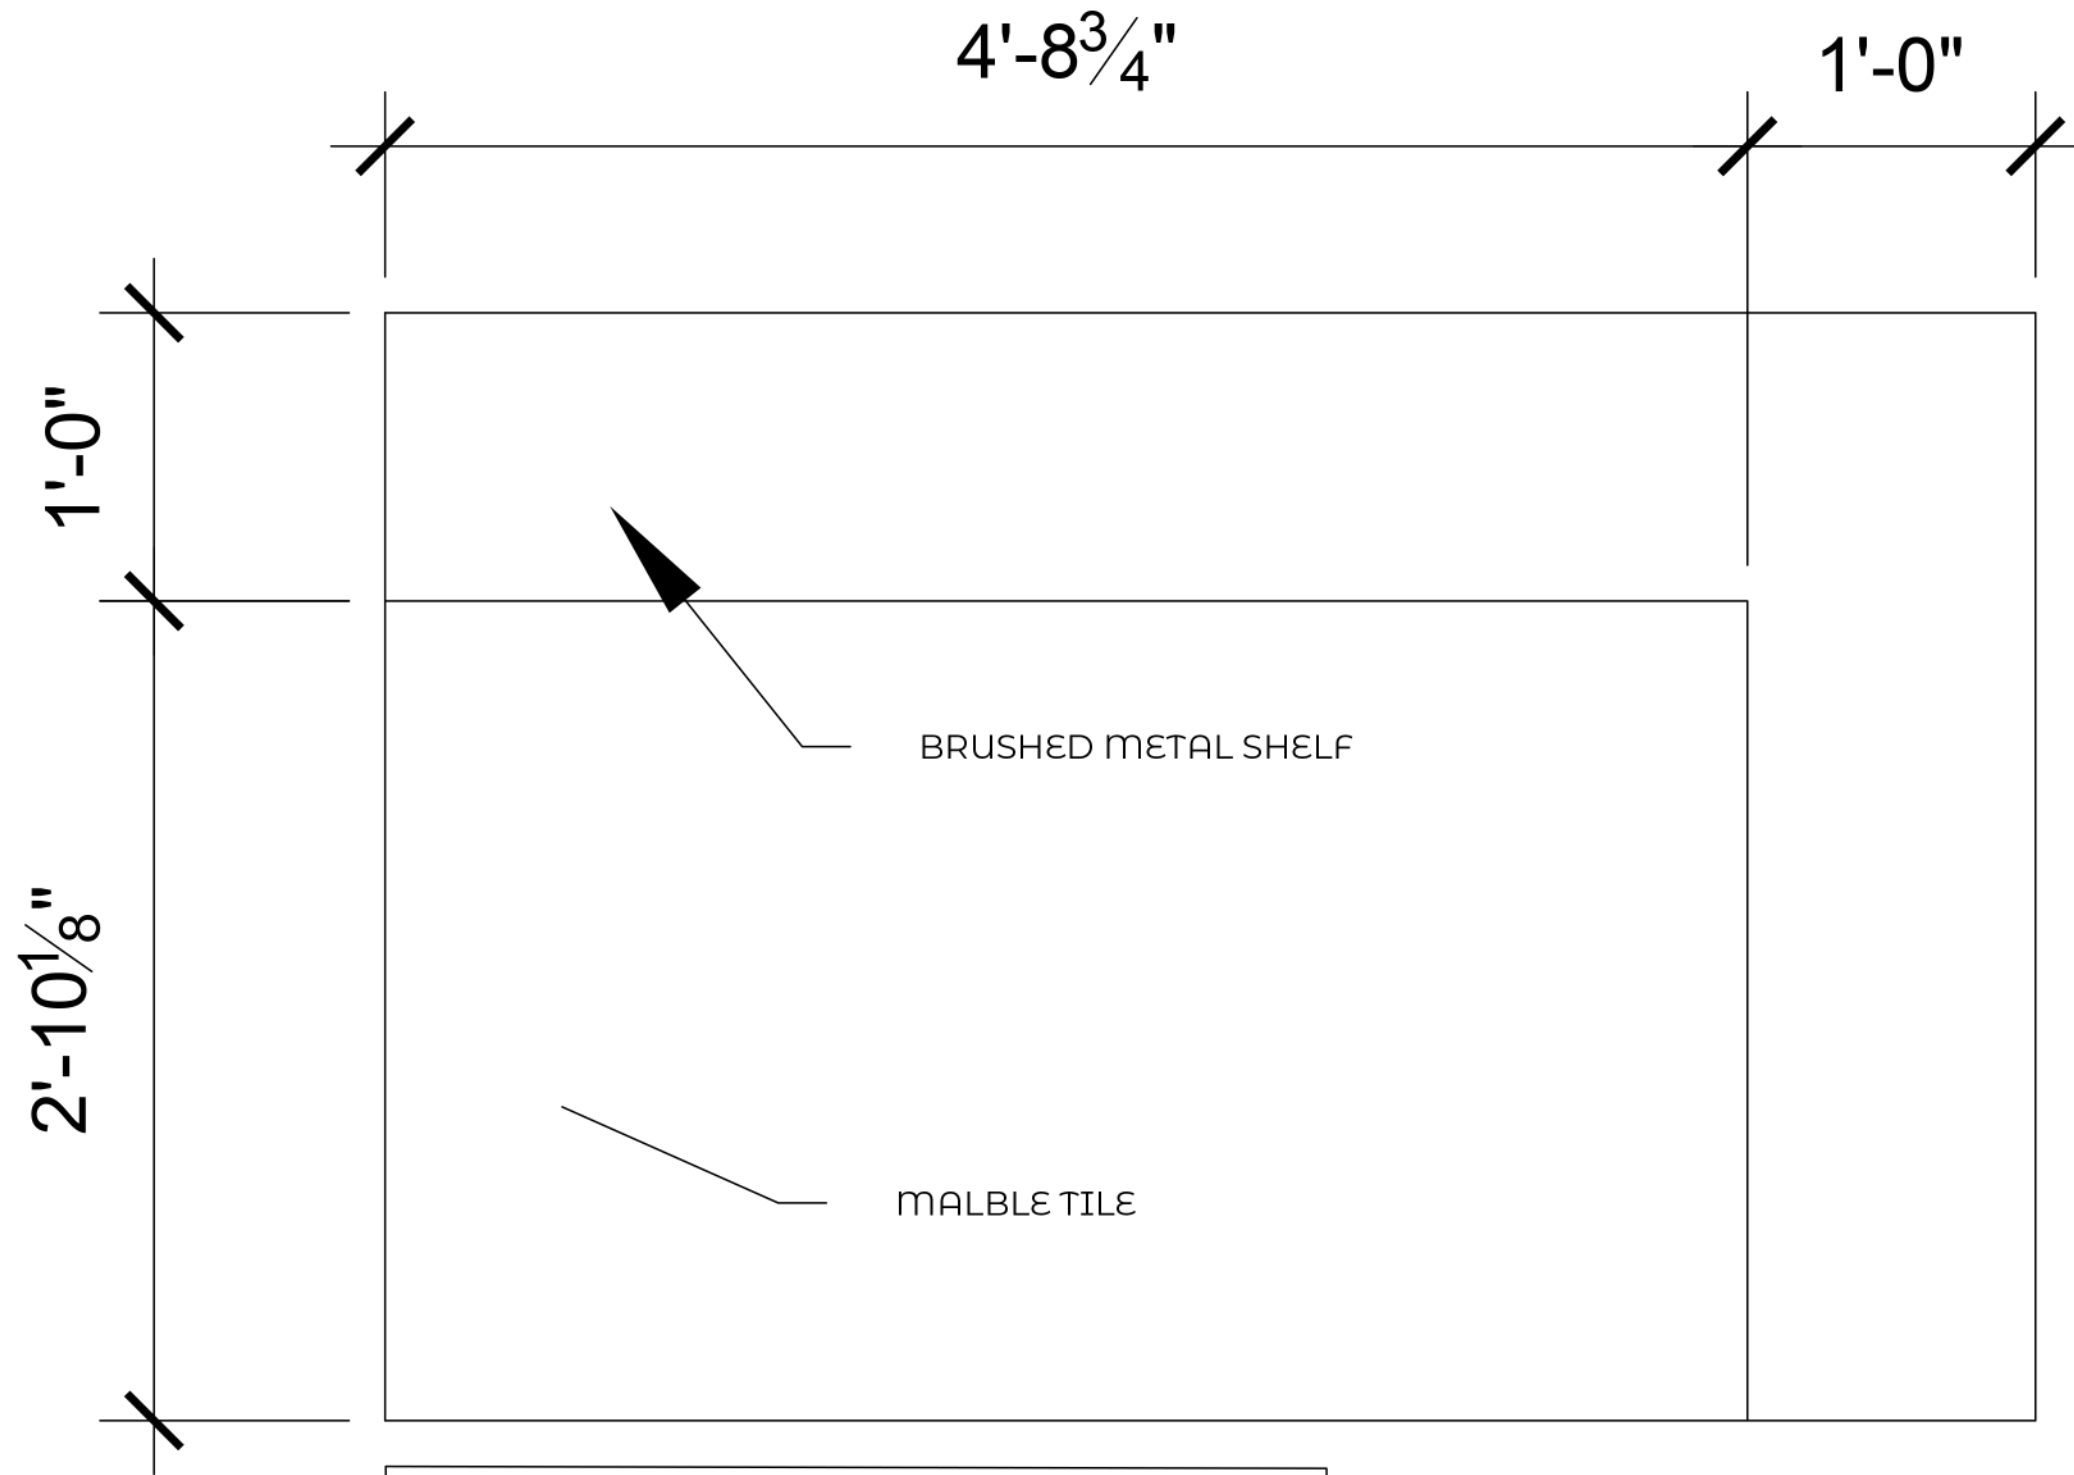

1 ISLAND DETAIL PLAN VIEW
A5.1 Scale: 1-1/2"=1'-0"
CLAUDIA FOLK WRIGHT

FolkWright Spaces

Claudia Folk Wright

Interior Designer
folk.claudia@gmail.com
(719) 244-7825
www.folkwrightspaces.weebly.com

JOHNSON
FURNITURE
SCHEDULE

PROJECT:
Heritage School
of Interior Design
AutoCAD Final Project


6/27/2019

PAGE

A6.1

Furniture Legend

#	CATEGORY	ITEM	MANUFACTURER	PRODUCT #	COLOR/FINISH	DIMENSIONS	Q
LR5	FURNITURE	OTTOMAN				24" X 24"	1
LR2	FURNITURE	CHAIR	Arhaus	3A01592AMB	Black Leather	29"W x 32"D x 34"H	2
ST1	FURNITURE	CLIENT CHAIR	William Sonoma	59-7831954	Rose	24"W x 23"D x 34.5H	2
LR1	FURNITURE	SOFA	Crate & Barrel	4768HG4	Harmony Latte	90"W x 63"D x 32"H	1
LR3	FURNITURE	COFFEE TABLE	145 Antiques	NA	Marble/Bronze Smoke	36" L X 22"D X 18.5"H	1
K1	FURNITURE	BAR CHAIR	Arteriors	DP5004	Blonde Oak/Leather	23"W x 19"D x33.5"H	4
ST3	FURNITURE	WRITING DESK	William Sonoma	58-2768179	Ebony/Gold	52"W x24.5 D x 30.5"H	1
ST2	FURNITURE	OFFICE CHAIR	CB2	509123	Rouka Grey	29"W x27.5"D x 34.5"H	1
H2	FURNITURE	PEDESTAL	John Richard	NA	Calcite	11"W x 11"D x 43"H	1
H1	FURNITURE	UPRIGHT DESK	William Sonoma	1023938	Ebony/Gold	44.5"W x 19"D x 52"H	1
BR2	FURNITURE	BEDSIDE TABLE	William Sonoma	1043954	Ebony/Gold	23.5"W x 16.25"D x 28"H	2
BR1	FURNITURE	BED	West Elm	4990326	Black Herringbone	82.6"W x 85"D x 56"H	1
LR4	ACCESSORY	RUG	William Sonoma	59-9527495	Grey	8' x 10'	1
LT3	ACCESSORY	BEDSIDE LAMP	Port 68	60P18	Gold	17"DIA x 28"H	2
A1	ACCESSORY	PILLOW	William Sonoma	4108018	Plaid	22"X22"	1
A2	ACCESSORY	PILLOW	William Sonoma	59-13265-40	Plaid	11"X22"	1
A3	ACCESSORY	PILLOW	William Sonoma	61-179339	Blush	22"X22"	1
A4	ACCESSORY	PILLOW	William Sonoma	61-1368777	Black	22"X22"	1
A5	ACCESSORY	THROW	William Sonoma	89-7654	Cotton Weave	50"X60"	1
CC1	ACCESSORY	ART	Tara Kelley-Cruz	NA	NA	2'X4'	1
CC2	ACCESSORY	ART	Tara Kelley-Cruz	NA	NA	17"X21"	1
CC3	ACCESSORY	ART	Tara Kelley-Cruz	NA	NA	17"X21"	1
BR3	ACCESSORY	RUG	West Elm	7893403	Indra	5'X8'	1
BR4	ACCESSORY	DUVET	Anthropologie	45405651AA	Grey Stripe	NA	1
AB6	ACCESSORY	MIRROR	CB2	115672	Brass	24" DIAM	3
FB2	DRAPERY	HARDWARE	CB2	363757	Brushed Brass	48"-88".75DIAM	3
FB3	DRAPERY	SHADE	The Shade Store	NA	Grey Wool	3'X6'	2
FB4	DRAPERY	ROMAN SHADE	The Shade Store	NA	Grey Wool	84"X36"	1
FB5	DRAPERY	PLEATED SHADE	The Shade Store	NA	Natural Grass	90"X36"	1
FB6	DRAPERY	PLEATED SHADE	The Shade Store	NA	Flax Herringbone	42"X36"	1

 JOHNSON FURNITURE SCHEDULE
Scale: 1/4"=1'-0"
CLAUDIA FOLK WRIGHT


JOHNSON
FINISH
SCHEDULE

PROJECT:
Heritage School
of Interior Design
AutoCAD Final Project

6/27/2019

PAGE
A6.2

FINISH LEGEND							
SYMBOL	CATEGORY	ITEM	COLOR/FINISH	Product #	Manufacturer	Dimensions	Quantity
D-2	Wall Finish	Forscari Fresco/Wall Covering	Peonia Grande	PDTG10-01	Designer's Guild	4.7"X9"	4
D-3	Wall Finish	Mulberry Home/Shetland Plaid Wall Covering	Lovat	FG086 R106	Mulberry Home	2'-3" x 32"	3
D-4	Wall Finish	Scalamandri Callisto Silk Weave Wall Covering	Doeskin	WP88359-004	Scalamandri	43"x12"	5
D-5	Wall Finish	Scalamandri Oxford Herringbone Weave	Flax	WP85339	Scalamandri	5'-12"	5
D-6	Wall Finish	Benjamin Moore Paint	Silver Fox	2108-50	Benjamin Moore	GALLON	NA
D-9	Wall Finish	Benjamin Moore Paint	Chantilly Lace	2121-70	Benjamin Moore	GALLON	NA
D-1	Wall Finish	Benjamin Moore Paint	Collingwood	OC-28	Benjamin Moore	GALLON	NA
D-8	Wall Finish	Builder Depot/Herringbone Polished Mosaic Tile	Nero Marquina	BLKP-1X2-HERRB	Builder Depot	1"x2"	NA
D-7	Wall Finish	Dal Tile Panoramic Porcelain Slab Backsplash	Calacutta	CM03	DAL TILE	18"X36"	NA
C-1	Flooring	Decorative Materials/Porcelain Gesso Tile/16"x32"	Taupe Linen	NA	Decorative Materials	16"-32"	NA
C-4	Flooring	Arigoni Woods/Oak 9"x4'	Brushe Hyde St	AC33	Arigoni Woods	240x15"	NA
C-2	Flooring	Builder Depot/Herringbone Honed Mosaic Tile 1"-3"	Nero Marquina	BLKP-1X2-HERRB	Builder Depot	1"x2"	NA
E2	Hard Surfaces	Dal Tile Panoramic Slab/Counter/Vanity	Calacutta	CM03	Dal Tile	18"x36"	NA
m1	Millwork	Ikea/Tyngsryd Cabinets	Wood Effect Black	NA	Ikea	NA	NA
B-1	Base Finish	Natural Strand Bamboo Baseboard	Raw	10012230	Natural Strand	6ft	NA
AP4	Appliance	Whirlpool French Door Refrigerator 36"x33"x68" ENERGY STAR RATED	Sunset Bronze	WRF335SWHN	Whirlpool	36"x33"x68"H	1
AP3	Appliance	Whirlpool Steep Tub Pocket Handle Dishwasher 22"x33.5"x33.5" ENERGY STAR RATED	Sunset Bronze	WDTA505OSAHN	Whirlpool	23"x33.5"x33.5"d	1
AP1	Appliance	Hallman/Duel Fuel Italian Range Gas Stove 30"x36"	Glossy Black	HDFR30BSGB	Hallman	30"x36"H	1
AP2	Appliance	Bristol/Copper Range Hood 36"x48"	Dark Antique	CSH-5891	Bristol	36"x48"H	1
AP5	Appliance	Electrolux Stacked Washer/Dryer 27"x32"x38"H	Titanium	MS255E	Whirlpool	27"x32"x38"H	1
K-4	Plumbing	Signature Hardware/Polished Marble Farmhouse Sink 30"x20"x10"	Cararra	943641	Signature Hardware	30"x20"x10"	1
PR1	Plumbing	Perrin & Rowe Deco Pedestal Sink 24"x25.5"x35.5"	White	U.2933WH	Perrin & Rowe	24"x25.5"x35.5"	1
PR2	Plumbing	Perrin & Rowe Deco Toilet	White/Italian Brass	U.KIT112-IB	Perrin & Rowe	+1/4'	1
F1	Plumbing	Rohl/Graceling U-line Lavatory Faucet	French Brass	MB2009DMFB-2	Rohl	+1/4'	1
F2	Plumbing	Rohl/Graceline Wall Mount Lavatory Faucet	French Brass	MB2030LMFB-2	Rohl	8"X2"	2
F3	Plumbing	Signature Hardware/Isadora Bar & Kitchen Faucet	Polished Brass	897654	Signature Hardware	12"X8"	1
MB1	Plumbing	Signature Hardware/3cm Marble Vanity top sinks	Cararra	654398	Signature Hardware	6'X3'	2

 JOHNSON FINISH SCHEDULE
Scale: 1/4"=1'-0"
CLAUDIA FOLK WRIGHT