

MINGLE COFFEE BAR


MARCH 13,2019

SHEET INDEX

A0	COVER
AD100	DEMO PAGE
A100	PROPOSED FURN. PLAN
A101	PROPOSED PLAN
A102	REFLECTED CEILING PLAN
A200	ELEVATION VIEWS
A300	INTERIOR PERSPECTIVES
A301	INTERIOR PERSPECTIVES

No.	Description	Date

COVER		
Project number	Project Number	A0
Date	03-13-2019	
Drawn by	Author	
Checked by	Checker	Scale 12" = 1'-0"

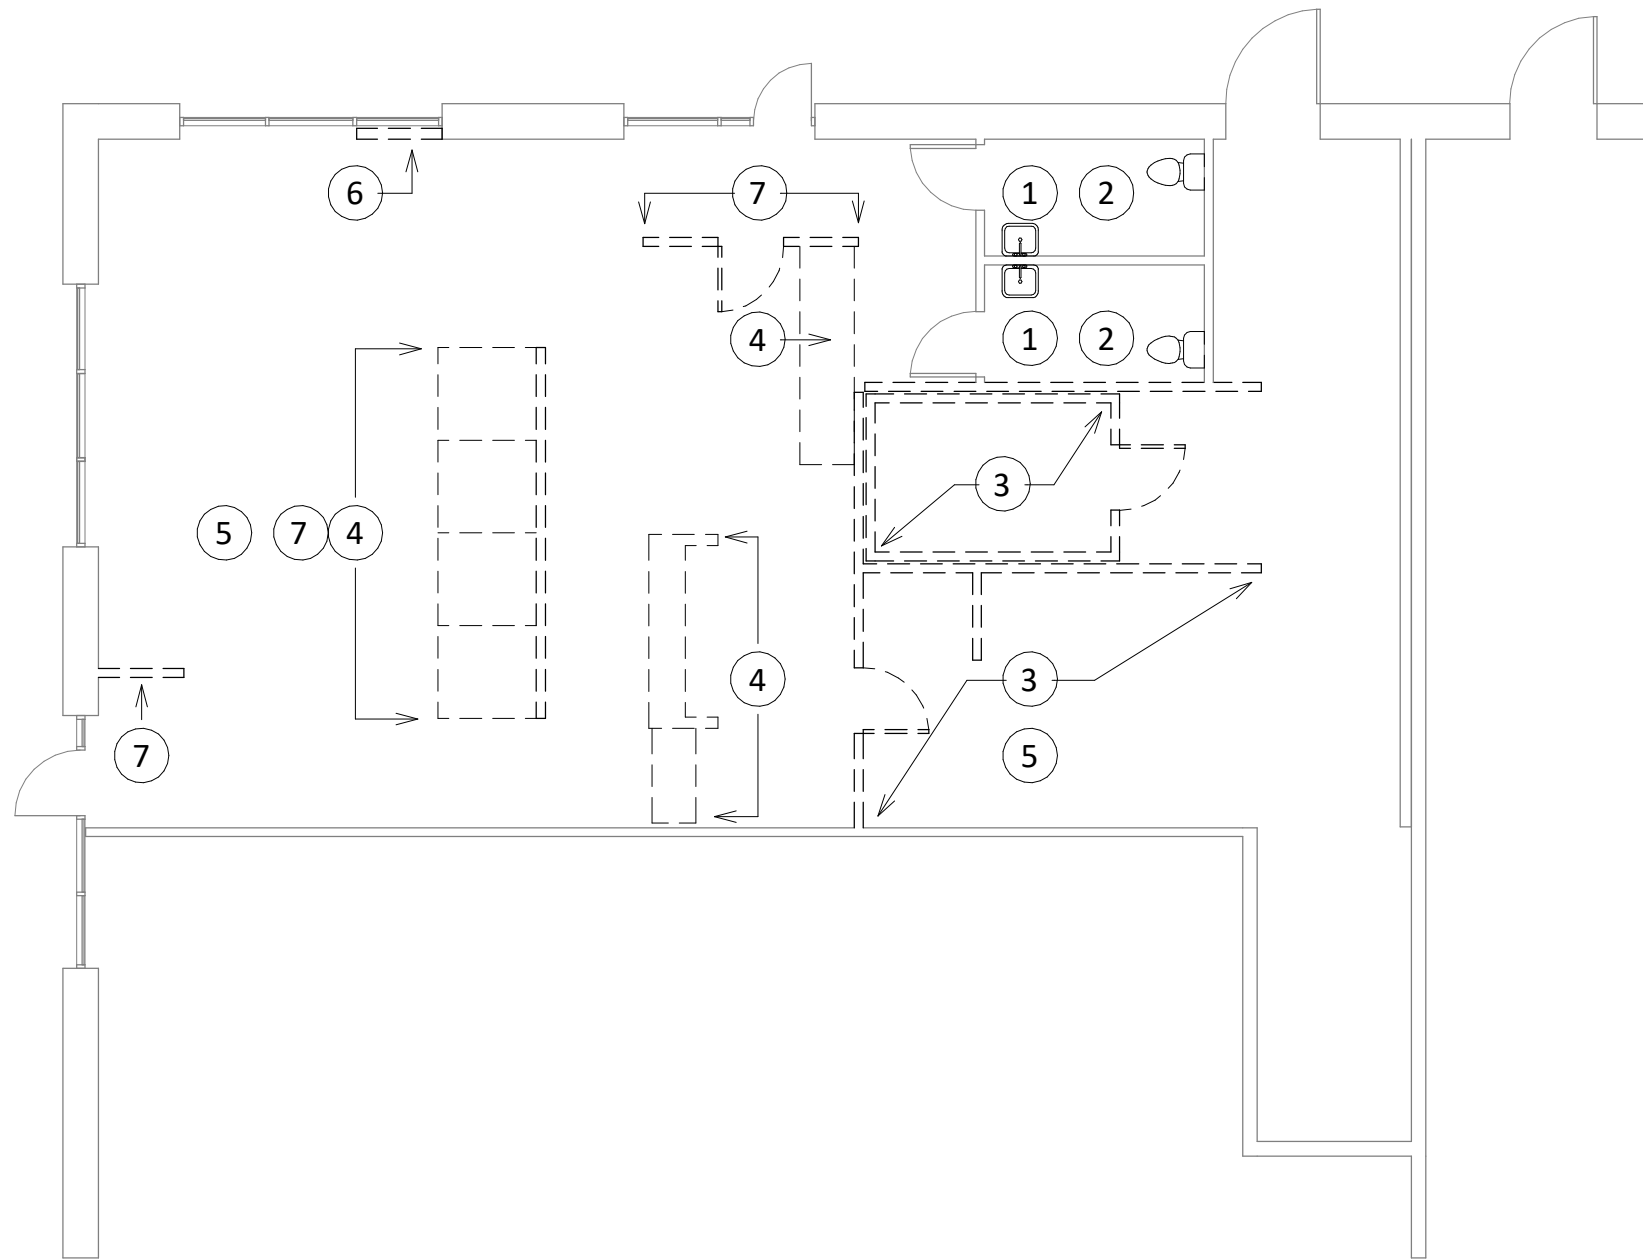

DEMO NOTES

- 1 DEMO EXISTING VANITY/PLUMBING FIXTURES
- 2 DEMO EXISTING BATHROOM FLOORING & WALL FINISH MATERIALS IN PREPARATION FOR NEW TILE
- 3 DEMO EXISTING WALLS IN PREPARATION FOR NEW KITCHEN AREA
- 4 DEMO EXISTING COUNTERS (WILL NOT REPLACE)
- 5 DEMO EXISTING FLOORING MATERIAL IN PREPARATION FOR NEW FLOOR MATERIAL
- 6 DEMO WALL (TO EXPOSE MORE OF THE EXISTING WINDOW)
- 7 DEMO WALL FOR GENERAL SPACE RECONFIGURATION

1 DEMO - Level 1
1/8" = 1'-0"




MINGLE COFFEE BAR

No.	Description	Date

DEMO PLAN

Project number	Project Number	AD100
Date	03-13-2019	
Drawn by	Author	
Checked by	Checker	Scale 1/8" = 1'-0"

3/13/2019 5:34:49 PM

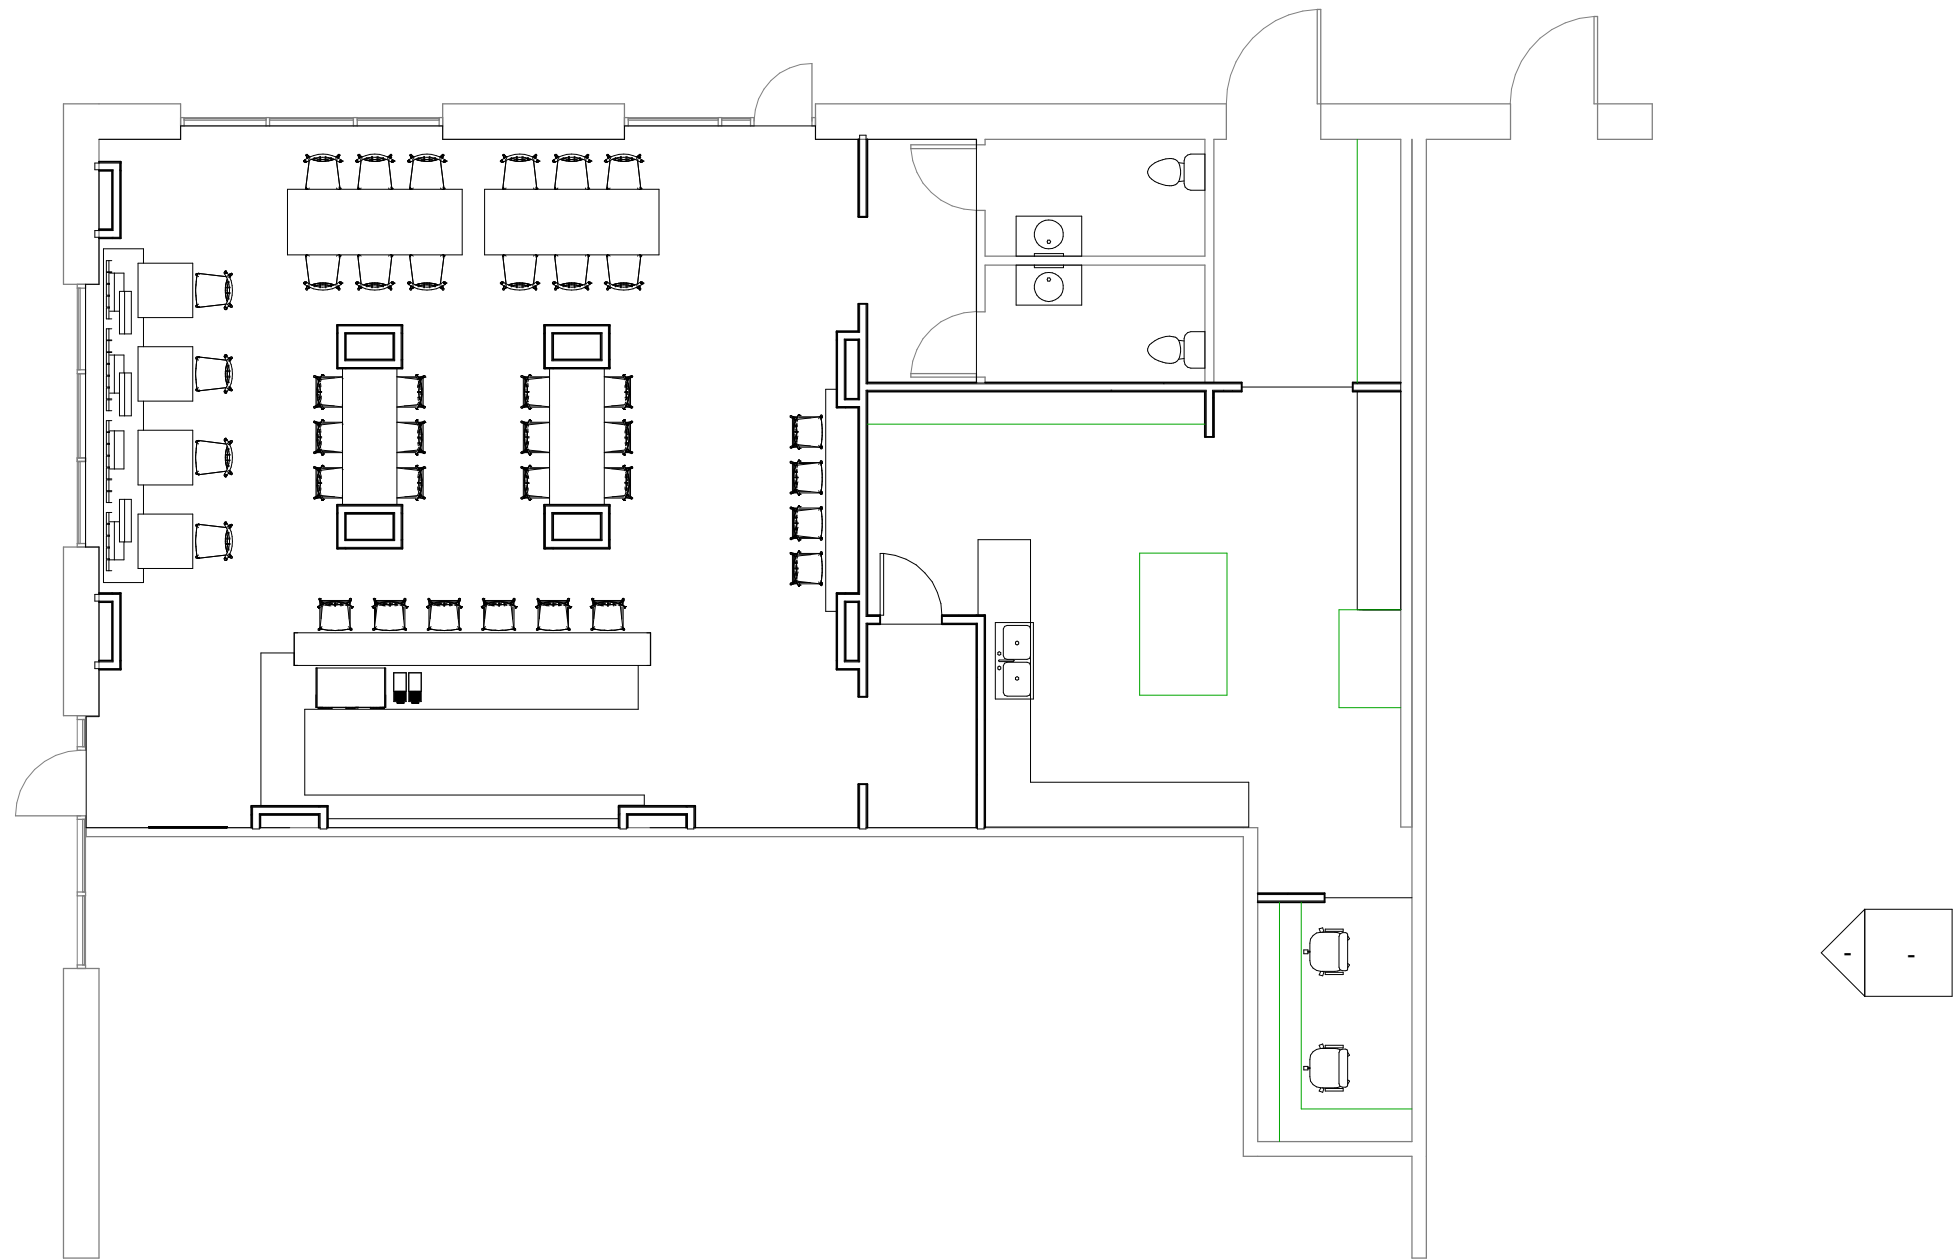

① Proposed - Level 1
1/8" = 1'-0"




HERITAGE
SCHOOL of INTERIOR DESIGN

MINGLE COFFEE BAR


No.	Description	Date

PROPOSED FURN PLAN

Project number	Project Number	A100
Date	03-13-2019	
Drawn by	Author	
Checked by	Checker	Scale 1/8" = 1'-0"

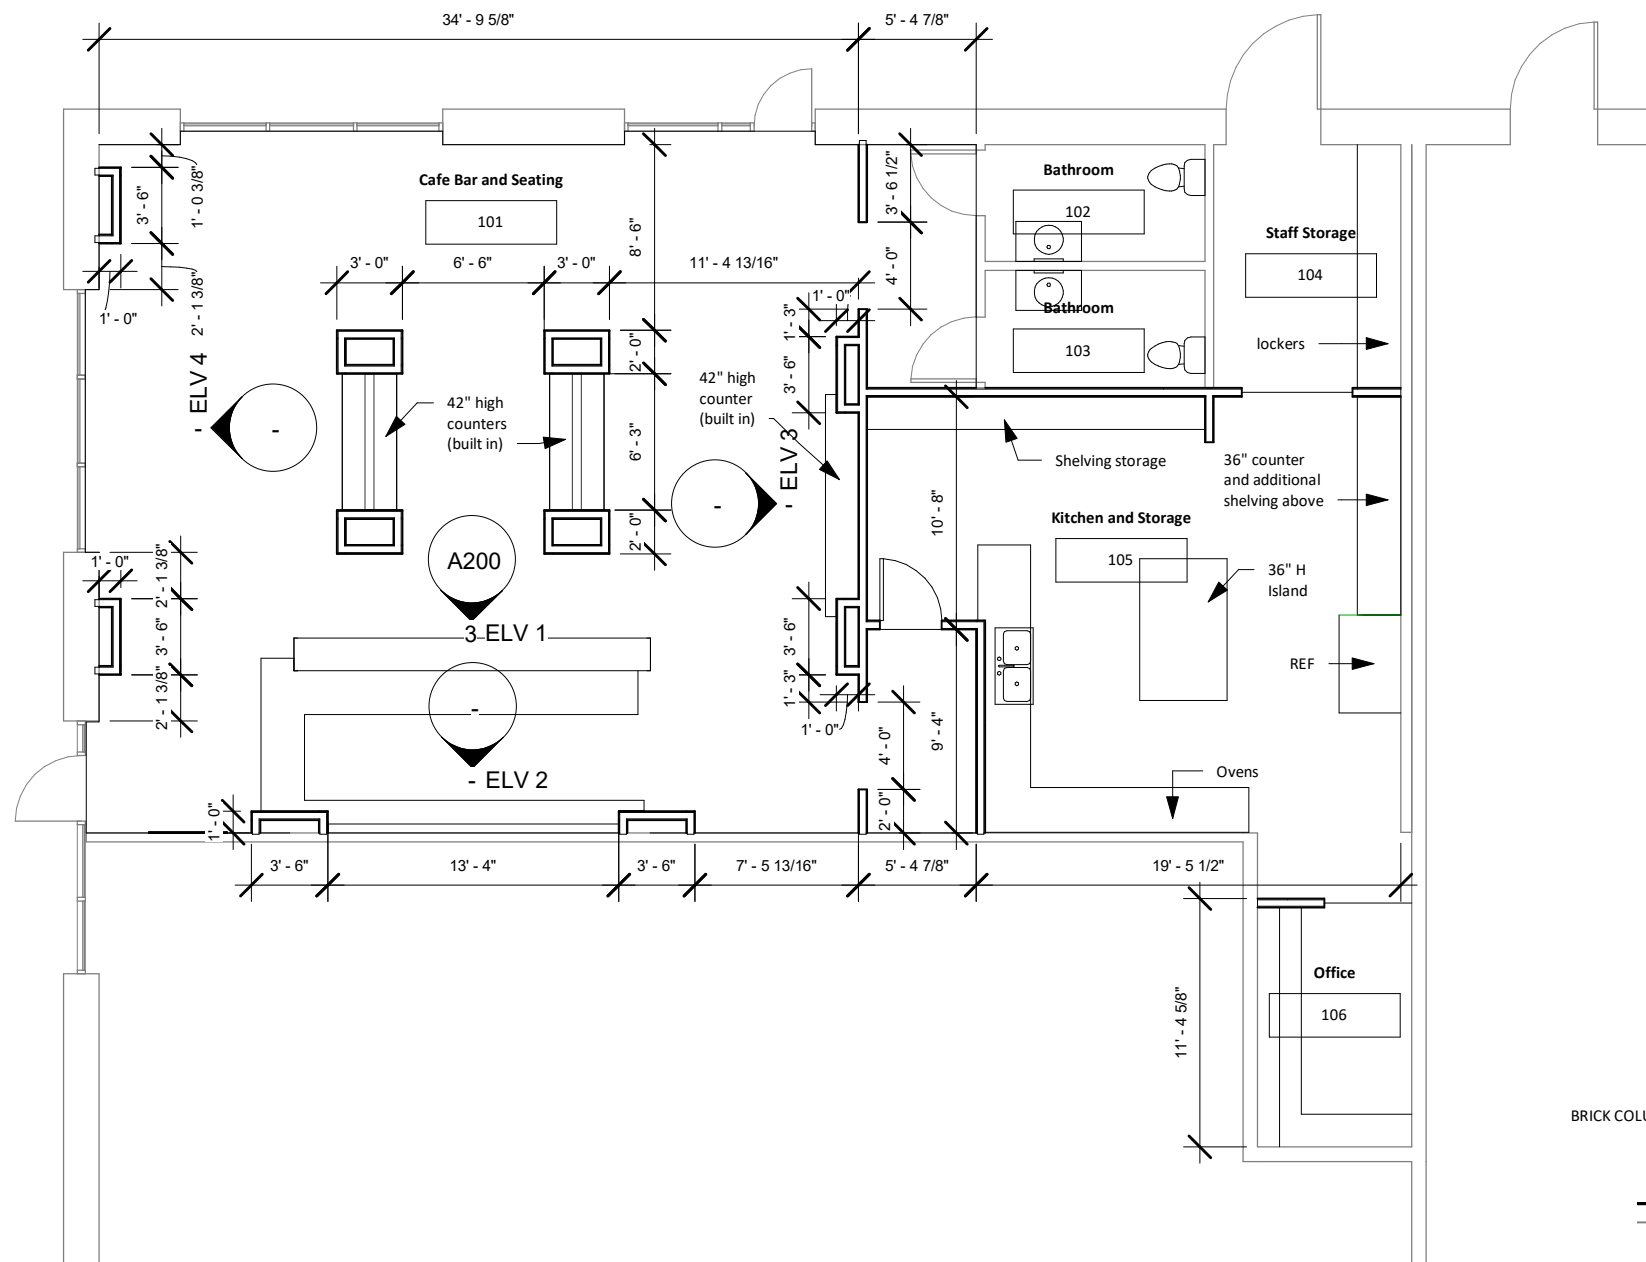


① Proposed - Level 1 (NO FURN)
1/8" = 1'-0"

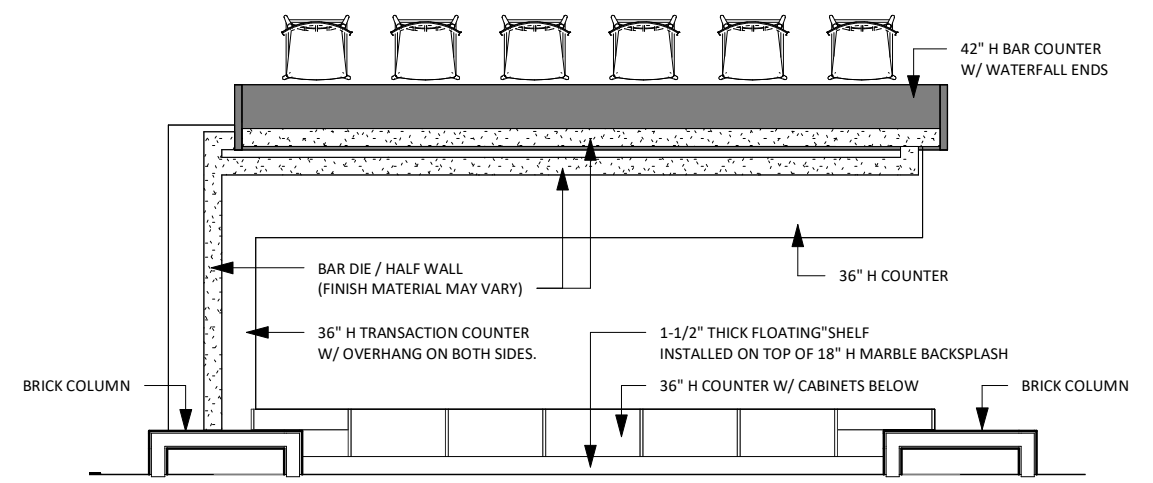

② Proposed - Level 1 - Bar Detail
1/4" = 1'-0"

No.	Description	Date

Project number	Project Number	A101
Date	03-13-2019	
Drawn by	Author	
Checked by	Checker	Scale As indicated

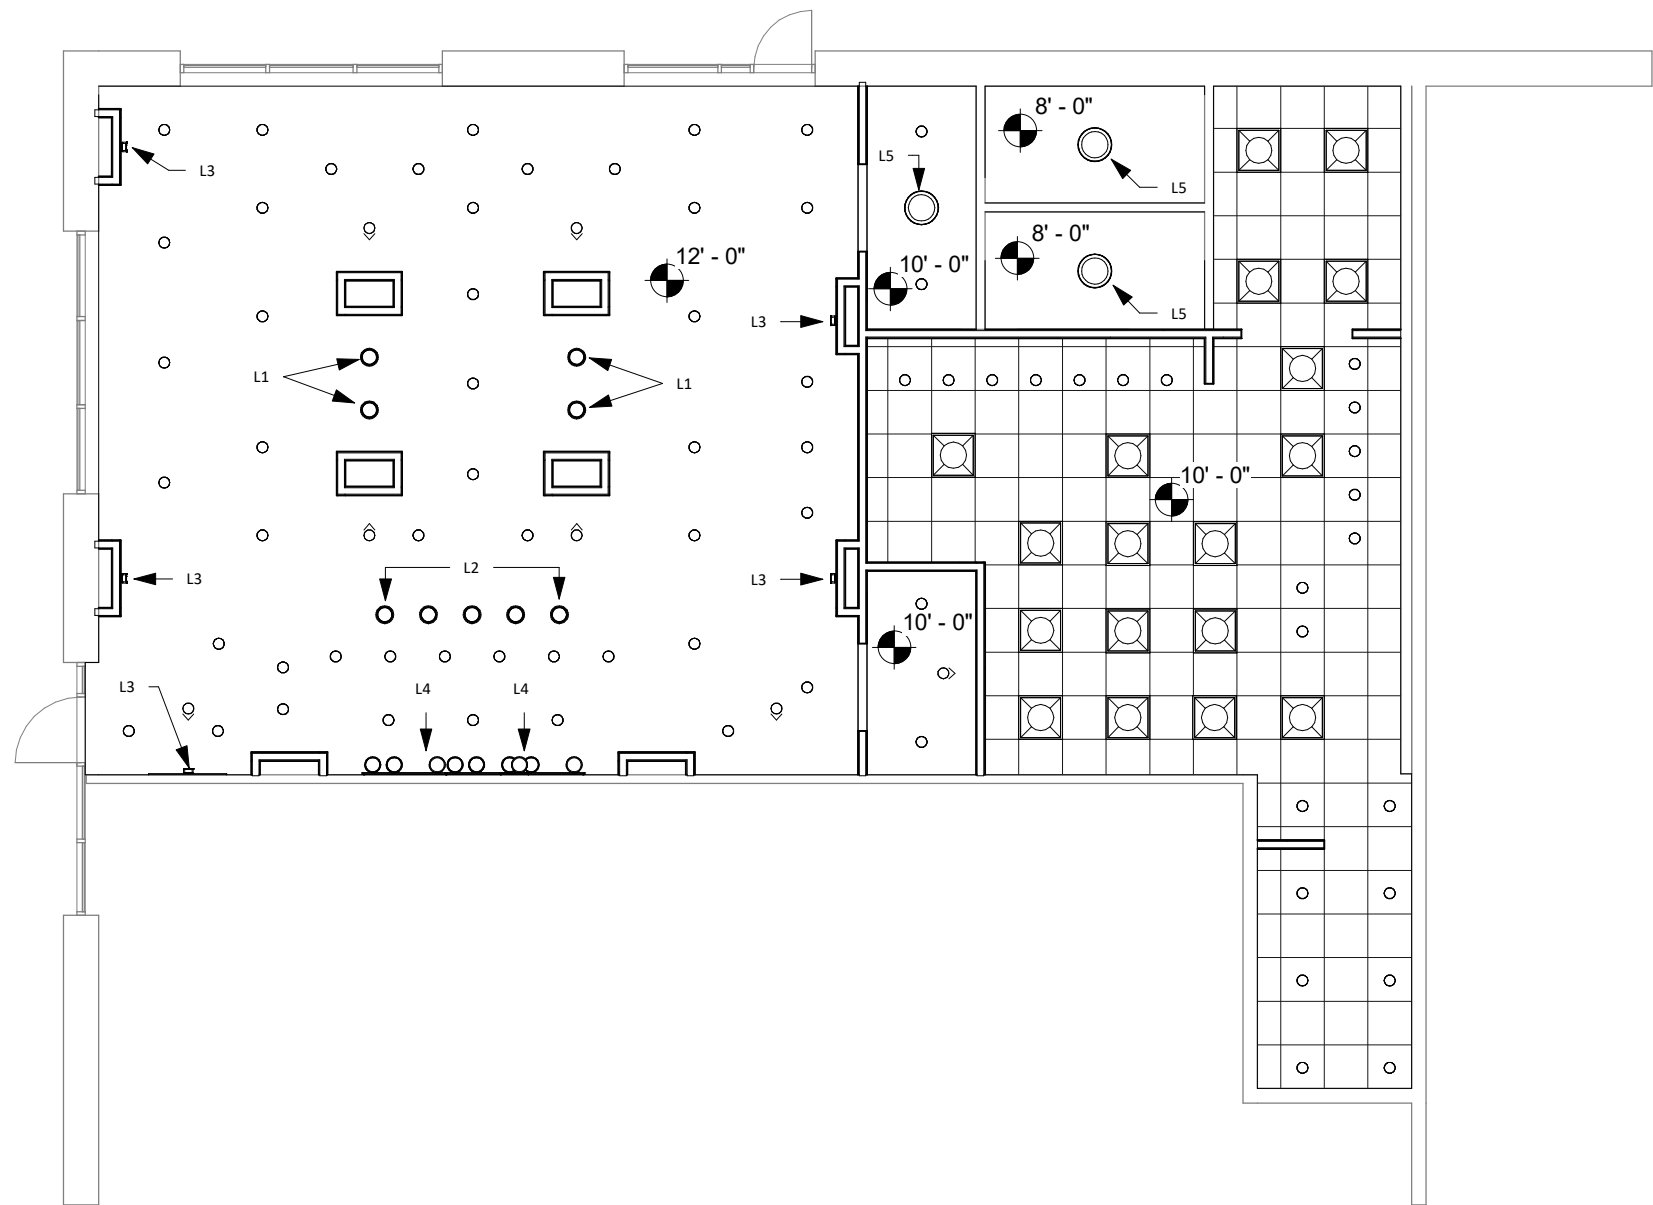

1 Proposed - Level 1
1/8" = 1'-0"




Key Decorative Fixtures

LABEL	TYPE	MFG / ITEM # / NAME
L1	PENDANT	VIBIA / 3726 / PALMA
L2	PENDANT	VIBIA / 3720 / PALMA
L3	SCONCE	RICH BRILLIANT WILLING / CR-S1 / CRISP
L4	SCONCE	VIBIA / 3704 / PALMA
L5	CEILING FM	VIBIA / 4870 / DUO




No.	Description	Date


Project number	Project Number	A101
Date	03-13-2019	
Drawn by	Author	
Checked by	Checker	Scale 1/8" = 1'-0"

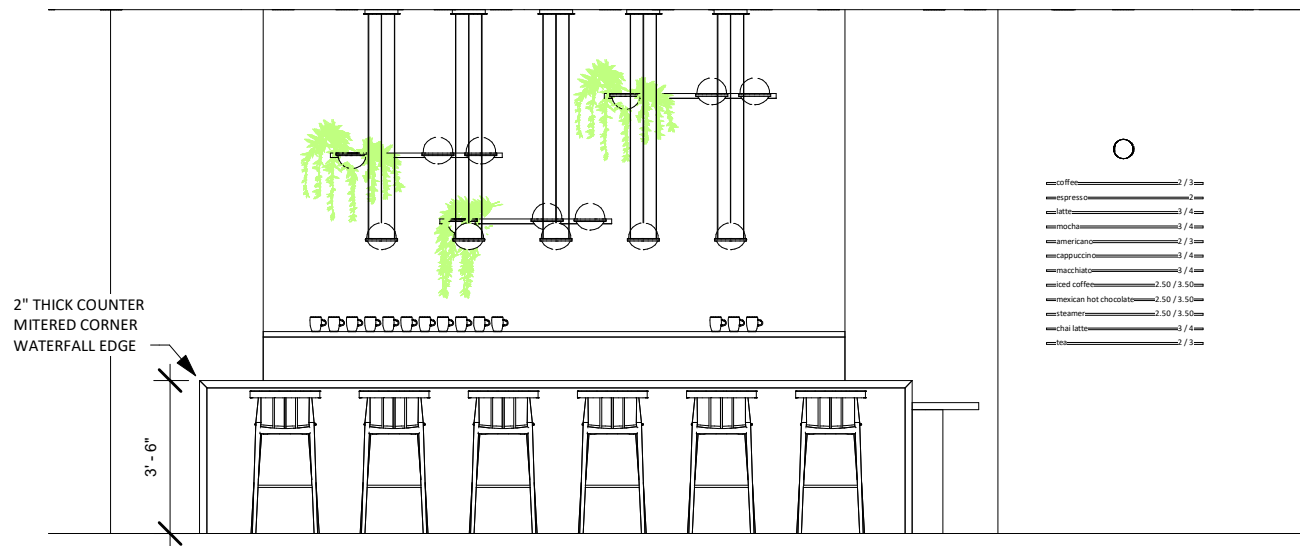

③ ELV 1
1/4" = 1'-0"

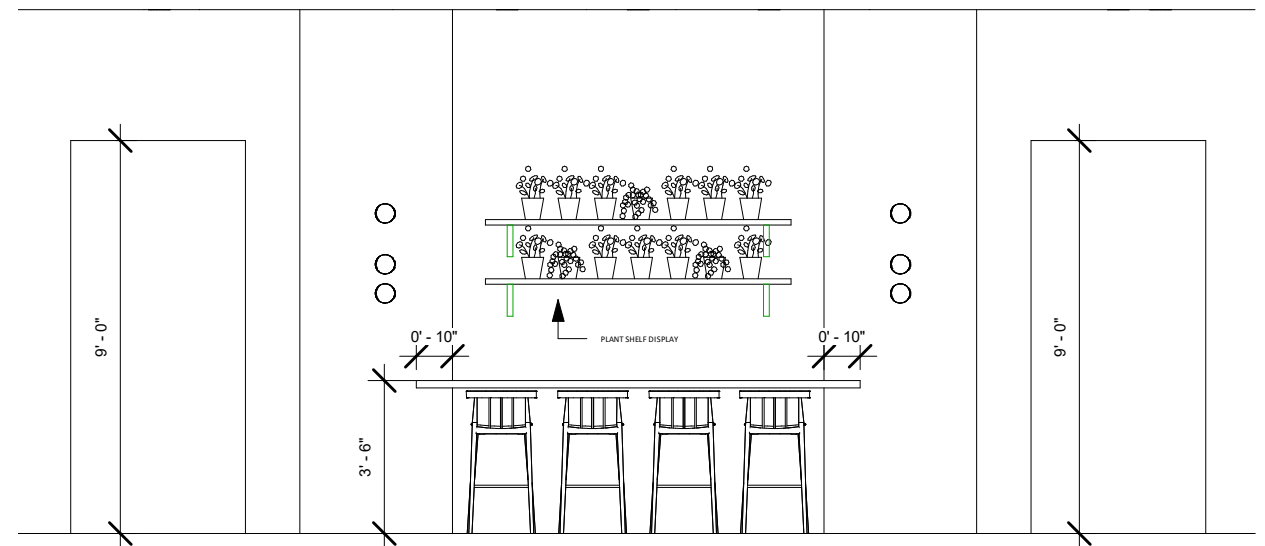

② ELV 3
1/4" = 1'-0"

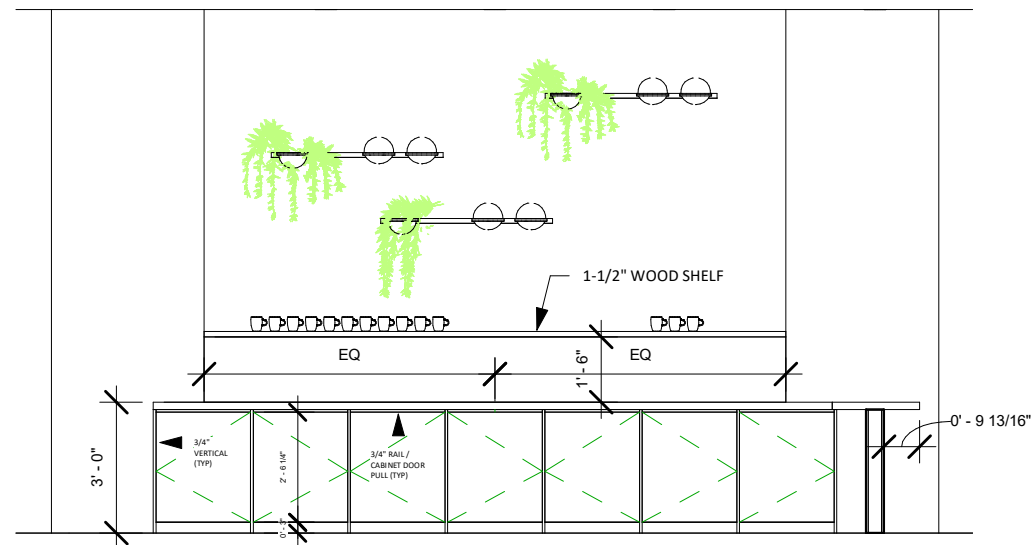

① ELV 2
1/4" = 1'-0"




PLANT SHELF EXAMPLE



CABINETRY INSPIRATION

No.	Description	Date

INTERIOR ELEVATIONS		
Project number	Project Number	A200
Date	03-13-2019	
Drawn by	Author	
Checked by	Checker	
		Scale 1/4" = 1'-0"

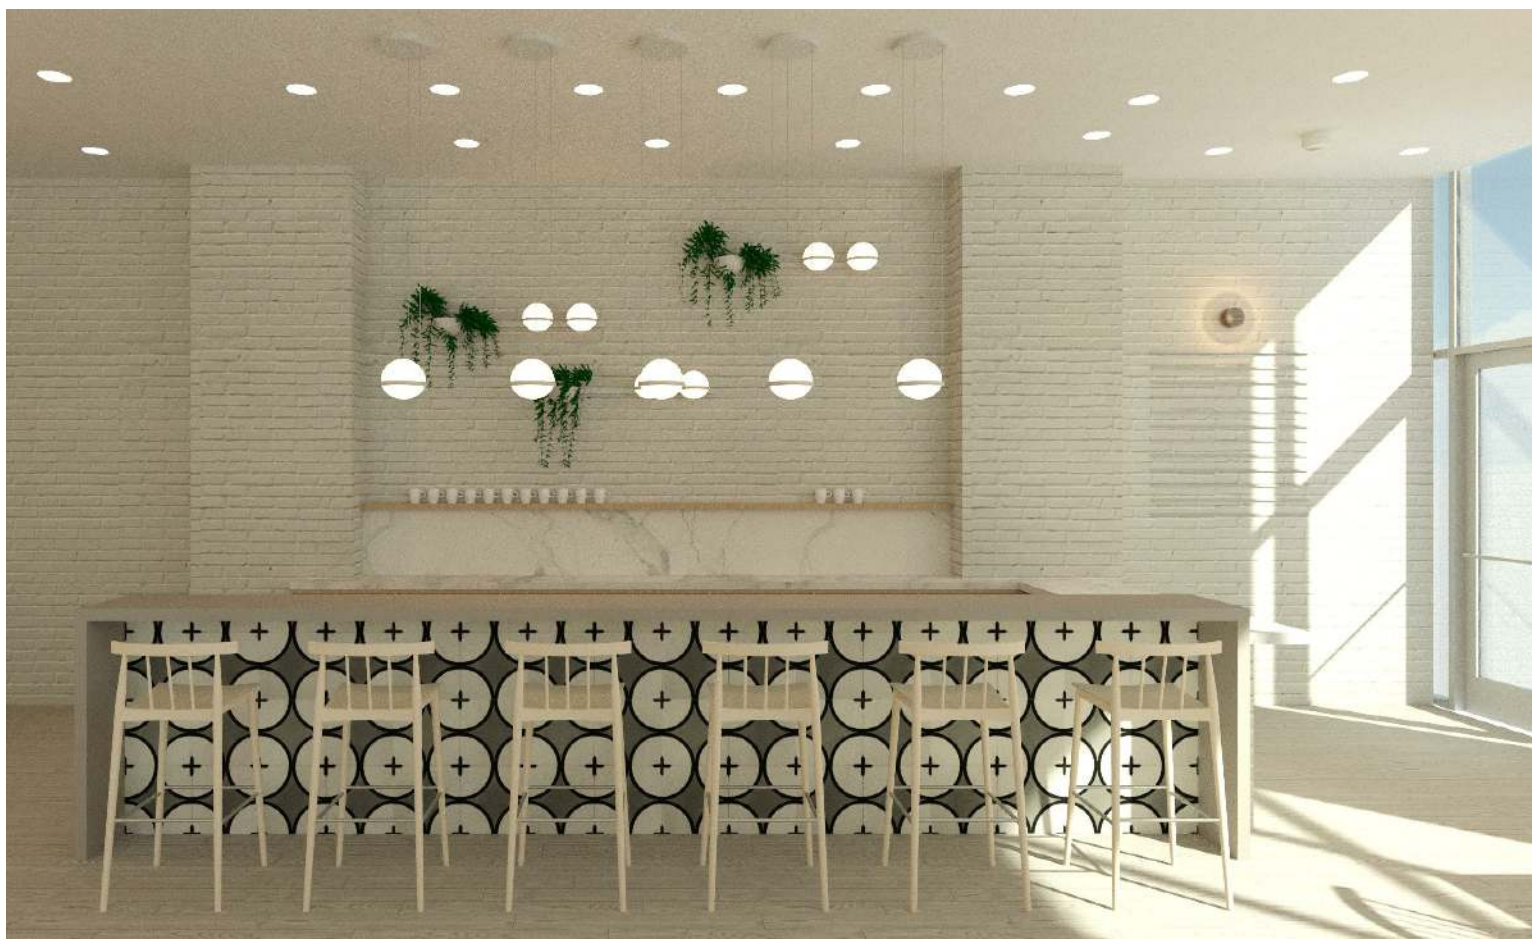


① Coffee Bar Front Rendering
12" = 1'-0"



Sconces w/ Plant



Coffee Bar
Cabinetry Inspiration

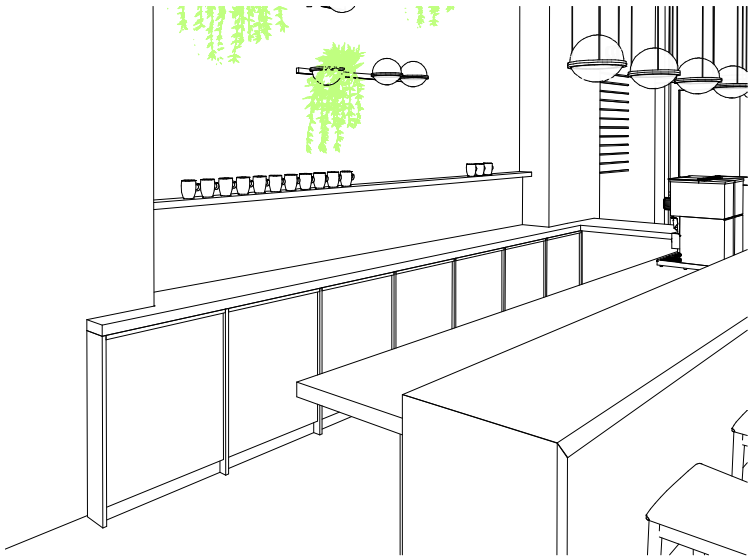

③ Back Bar



② Angled Bar Order Counter



MINGLE COFFEE BAR

No.	Description	Date

INTERIOR PERSPECTIVES		
Project number	Project Number	A300
Date	03-13-2019	
Drawn by	Author	
Checked by	Checker	
		Scale 12" = 1'-0"



① Cafe Seating
12" = 1'-0"



② Window Seating
12" = 1'-0"



No.	Description	Date

INTERIOR PERSPECTIVES		
Project number	Project Number	A301
Date	03-13-2019	
Drawn by	Author	
Checked by	Checker	Scale 12" = 1'-0"